

17	M11	主机海水冷却备用泵 M/E S.W. COOLING STANDBY PUMP	3φ 380V 18.5kW	1	
16	M8	齿轮箱滑油备用泵 GEARBOX L.O. STDBY PUMP	3φ 380V 15kW	1	
15	M7	消防泵 FIRE PUMP	3φ 380V 45kW	1	
14	M6	主机海水冷却泵 M/E S.W. COOLING PUMP	3φ 380V 18.5kW	1	
13	M5	海水淡化装置海水泵 BALLAST WATER PUMP	3φ 380V 11kW	2	
12	M4	主机燃油供给备用泵 M.E.F.O SUPPLY STANDBY PUMP	3φ 380V 0.75kW	1	
11	M3	主机滑油备用泵 M/E L.O. STANDBY PUMP	3φ 380V 22kW	1	
10	M2,M10	燃油输送泵 F.O. TRANSFER PUMP	3φ 380V 2.2kW	2	
9	M1,,M9	机舱风机(可逆) E/R FAN (REVERSIBLE)	3φ 380V 7.5kW	2	
8	1~3AST	发电机自启动装置 GENERATOR AUTO START SET		3	设备配套 SUPPLIED WITH SYS.
7	1~4SM	发电机组调速装置 REVOLUTION ADJUST EQUIPMENT		4	设备配套 SUPPLIED WITH SYS.
6	1~4AVR	发电机自动调压器 VOLTAGE ADJUST EQUIPMENT		4	设备配套 SUPPLIED WITH SYS.
5	4G	NO.4发电机 NO.1~3 GENERATOR	3φ 400V 150kW 50Hz	1	
4	1~3G	NO.1~3发电机 NO.1~3 GENERATOR	3φ 400V 400kW 50Hz	3	
3	WHC	驾驶室集中控制台 WHEELHOUSE CONTROL CONSOLE		1	
2	CHB	蓄电池充放电板 BATTERY CHARGING & DISCHARGING BOARD		1	
1	MSB	主配电板 MAIN SWITCHBOARD		1	
旧底图登记号					
底图登记号	序号	代 号	名 称 及 型 号	数量	备 注
	NO.	STANDARD OR DRAWING NO.	NAME & TYPE	QTY.	REMARKS

34	25ST	污油泵控制箱 SLUDGE OIL PUMP STARTER	1		
33	M25	污油泵 3φ 380V 1.5kW SLUDGE OIL PUMP	1		
32	22-24ST	制冷系统冷凝水泵控制箱 PUMP RM. FAN STARTER	3		
31	M22-24	制冷系统冷凝水泵 3φ 380V 18.5kW PUMP RM. FAN (EX.PROOF)	3		
30	1-3ERC	机旁操纵板 CONSOLE PANEL	3		
29	21ST	NO.3制冷压缩机起动箱 SLUDGE OIL PUMP STARTER	1		
28	M21	NO.3制冷压缩机 3φ 380V 160kW NO.3 REFRIGERANT COMPRESSOR UNIT	1		
27	19-20ST	NO.1-2制冷压缩机起动箱 NO.1-2 REFRIGERANT COMPRESSOR UNIT STARTER	2	设备配套 SUPPLIED WITH SYS.	
26	M19-20	NO.1-2制冷压缩机 3φ 380V 204kW NO.1-2 REFRIGERANT COMPRESSOR UNIT	2		
25	17-18MV	泄放电磁阀 SOLENOID VALVE	2	设备配套 SUPPLIED WITH SYS.	
24	17-18ST	空压机控制箱 NO.1 AIR COMPRESSOR C.B.	2	设备配套 SUPPLIED WITH SYS.	
23	M17-18	空压机 3φ 380V 7.5kW NO.1 AIR COMPRESSOR	2		
22	M16	燃油驳运泵 3φ 380V 7.5kW F.O. LIGHTERAGE PUMP	1		
21	M15	总用泵 3φ 380V 45kW GENERAL SERVICE PUMP	1		
20	M14	主机低温淡水备用泵 3φ 380V 11kW M.E. L.T. F.W COOLING STANDBY PUMP	1		
19	M13	主机高温淡水备用泵 3φ 380V 11kW M.E. H.T. F.W COOLING STANDBY PUMP	1		
18	M12	舱底总用泵 3φ 380V 11kW BILGE AND GENERAL SERVICE PUMP	1		
旧底图登记号					
底图登记号	序号	代 号	名 称 及 型 号	数 量	备 注
	NO.	STANDARD OR DRAWING NO.	NAME & TYPE	QTY.	REMARKS

旧底图登记号	底图登记号	序号 NO.	代 号 STANDARD OR DRAWING NO.	名 称 及 型 号 NAME & TYPE	数量 QTY.	备 注 REMARKS
		51	P-1	NO.1电力设备分电箱(机修设备) NO.1 POWER DISTRIBUTION BOX (WORKSHOP EQUIPMENT)	1	
		50	FIV	艏侧推电机启动柜 BOW SIDE PUSH MOTOR STARTER BOX	1	
		49	TW	液压拖网起网机启动箱 HYDRAULIC TRAWLING WINCH	1	
		48	TF	隧道式冷冻机 TUNNEL FREEZER	1	设备配套 SUPPLIED WITH SYS.
		47	1-2HDM	液压绞纲机启动箱 HYDRAULIC DREDGE MACHINE STARTER	2	设备配套 SUPPLIED WITH SYS.
		46	ETDP	蒸发式海水淡化装置 EVAPORATION TYPE. DESALINATION PLANT	1	设备配套 SUPPLIED WITH SYS.
		45	OWS	油污水分离器控制箱 OIL WATER SEPARATOR C.B.	1	设备配套 SUPPLIED WITH SYS.
		44	RODP	反渗透式海水淡化装置控制箱 REVERSE OSMOSIS DESALINATION PLANT C.B.	1	设备配套 SUPPLIED WITH SYS.
		43	1~2SGC	舵机控制箱 STEERING GEAR CONTROL BOX	2	设备配套 SUPPLIED WITH SYS.
		42	1~2MWP	艏绞机控制箱 MOORING WINCH HYP. PUMP C.B.	2	设备配套 SUPPLIED WITH SYS.
		41	AWP	锚机控制箱 ANCHOR WINDLASS HYP. PUMP C.B.	1	设备配套 SUPPLIED WITH SYS.
		40	LOSP	滑油分油机控制箱 L.O. PURIFIER C.B.	1	设备配套 SUPPLIED WITH SYS.
		39	1~2FOSP	燃油分油系统控制箱 F.O. PURIFIER C.B.	2	设备配套 SUPPLIED WITH SYS.
		38	27ST	吊机启动箱 CARGO WINCH STARTER	1	设备配套 SUPPLIED WITH SYS.
		37	M27	吊机 3ϕ 380V 22kW CARGO WINCH	1	
		36	26ST	日用舱底泵启动箱 QC91-20/13 FRONT BALLAST PUMP STARTER	1	
		35	M26	日用舱底泵 3ϕ 380V 2.2kW FRONT BALLAST PUMP	1	

68	NLP	航行灯控制箱 NAVIGATION LIGHT C.P.	1		
67	1~2HP	220V助航分电箱 220V NAVAID DISTRIBUTOR	2		
66	LD-7	NO.7照明分电箱 NO.7 LIGHTING DISTR. BOX	1		
65	LD-6	NO.6照明分电箱 NO.6 LIGHTING DISTR. BOX	1		
64	LD-5	NO.5照明分电箱 NO.5 LIGHTING DISTR. BOX	1		
63	LD-4	NO.4照明分电箱 NO.4 LIGHTING DISTR. BOX	1		
62	LD-3	NO.3照明分电箱 NO.3 LIGHTING DISTR. BOX	1		
61	LD-2	NO.2照明分电箱 NO.2 LIGHTING DISTR. BOX	1		
60	LD-1	NO.1照明分电箱 NO.1 LIGHTING DISTR. BOX	1		
59	SCB	岸电箱 3ϕ 380V 100A SHORE CONNECTION BOX	1		
58	1~2TR	照明变压器 CSGD-75 3ϕ 400V/230V 50Hz 75KVA LIGHTING TRANSFORMER	2		
57	P-7	NO.7电力设备分电箱(生活设备) NO.7 POWER DISTRIBUTION BOX (DOMESTIC INSTALLATION)	1		
56	P-6	NO.6电力分电箱(电暖器) NO.6 POWER DISTRIBUTION BOX (ELECTRIC HEATER)	1		
55	P-5	NO.5电力分电箱(电暖器) NO.5 POWER DISTRIBUTION BOX (ELECTRIC HEATER)	1		
54	P-4	NO.4电力分电箱(电暖器) NO.4 POWER DISTRIBUTION BOX (ELECTRIC HEATER)	1		
53	P-3	NO.3电力设备分电箱(机舱水泵) NO.3 POWER DISTRIBUTION BOX (E/R WATER PUMP)	1		
52	P-2	NO.2电力设备分电箱(舱室风机) NO.2 POWER DISTRIBUTION BOX (FAN)	1		
旧底图登记号					
底图登记号	序号	代 号	名 称 及 型 号	数 量	备 注
	NO.	STANDARD OR DRAWING NO.	NAME & TYPE	QTY.	REMARKS

85	30~32LS	油箱低液位开关 L. LEVEL SWITCH IN OIL BOX	3	设备配套 SUPPLIED WITH SYS.	
84	30~32DPS	滤器压差开关 DIFFERENTIAL PRESSURE SWITCH	3	设备配套 SUPPLIED WITH SYS.	
83	M31~32	艙绞机液压油泵 3~380V 50Hz 30kW MOORING WINCH HYDRAULIC PRESSURE OIL PUMP	2		
82	M30	锚机液压油泵 3~380V 50Hz 22kW ANCHOR WINCH HYDRAULIC PRESSURE OIL PUMP	1		
81	28ST	日用艙底泵起动机 QC91-20/13 FRONT BALLAST PUMP STARTER	1		
80	M28	日用艙底泵 3φ 380V 2.2kW FRONT BALLAST PUMP	1		
79	~PSL	压力开关(低) PRESSURE SWITCH (L.)	2		
78	~FSL	液位开关(低) LEVEL SWITCH (L.)	2		
77	~FSH	液位开关(高) LEVEL SWITCH (H.)	2		
76	~EAP~	遥控按钮 LAS/J-1J EM'CY SHUT OFF BUTTON	6		
75	~RC~	遥控按钮 LAS/J-2-1D 18只 LAS/J-3-2D 2只 REMOTE BUTTON	20		
74	RCP	无线电充放电板 RADIO BATTERY CH.& DISCH. PANEL	1		
73	CO2P	CO2施放控制箱 CO2 RELEASE ALARM BOX	1		
72	EMC	机艙监视台 E/R MONITORING CONSOLE	1		
71	WP	无线电设备分电箱 P.D.P FOR RADIO EQUIPMENT	1		
70	FAP	火灾报警控制箱 FIRE ALARM C.P.	1		
69	SLP	信号灯控制箱 SIGNAL LIGHT C.P.	1		
旧底图登记号					
底图登记号	序号	代 号	名 称 及 型 号	数 量	备 注
	NO.	STANDARD OR DRAWING NO.	NAME & TYPE	QTY.	REMARKS

102	M40	厨房抽风机 3φ 380V 0.55kW	1	
		GALLEY EXHAUST FAN		
101	BO	电烤箱	1	
		BAKERY OVEN		
100	ERC	蒸饭箱 3φ 380V 6kW	1	
		ELECTRIC AND STEAM RICE BOLIER		
99	EK	电灶 3φ 380V 12kW	1	
		ELECTRIC RANGE		
98	ET	电工试验板	1	
		ELE. TEST PANEL		
97	M39	电动钻床 3φ 380V 0.75kW	1	
		BENCH DRILL		
96	M38	电动砂轮机 3φ 380V 0.6kW	1	
		GRINDER		
95	3M44	排气泵 3φ 380V 0.37kW	1	
		AIR PUMP		
94	2M44	排污泵 3φ 380V 1.5kW	1	
		DISCHARGE PUMP		
93	1M44	粉碎泵 3φ 380V 1.5kW	1	
		SUTTING PUMP		
92	STP	生活污水处理装置	1	设备配套 SUPPLIED WITH SYS.
		SEWAGE TREATMENT PLANT		
91	43EH	电加热器 3~ 380V 1kW	1	
		ELE.HEATER		
90	M43	舱底水泵电动机 3~ 380V 2.2kW	1	
		BILGE PUMP MOTOR		
89	35H	分油机电加热器 3φ 380V 9kW	1	
		SLUDGE PUMP		
88	M35	分油机电动机 3φ 380V 2.2kW	1	
		PURIFIRE MOTOR		
87	2M33~34	分油机供油泵 3φ 380V 1.5kW	2	
		TRANSFER PUMP		
86	1M33~34	分油机电动机 3φ 380V 2.2kW	2	
		PURIFIRE MOTOR		
旧底图登记号				
底图登记号	序号代 号	名 称 及 型 号	数量	备 注
	NO.	STANDARD OR DRAWING NO.	QTY.	REMARKS
		NAME & TYPE		


119	M49	洗衣间风机 WASHING RM. EXHAUST FAN	3φ 380V 0.25kW	1	
118	48ST	设备舱抽风机起动箱 EQUIPMENT TANK EXHAUST FAN STARTER	QC91-20/13	1	
117	M48	设备舱抽风机 EQUIPMENT TANK EXHAUST FAN	3φ 380V 0.55kW	1	
116	47ST	液压泵站风机起动箱 HYD.P. PUMP RM. EXHAUST FAN STARTER	QC91-20/13	1	
115	M47	液压泵站风机 HYD.P. PUMP RM. EXHAUST FAN	3φ 380V 0.25kW	1	
114	46ST	应急消防泵舱抽风机起动箱 STEERING GEAR RM. FAN STARTER	QC91-20/13	1	
113	M46	应急消防泵舱抽风机 STEERING GEAR RM. FAN	3φ 380V 0.25kW	1	
112	45ST	浴室抽风机起动箱 A.C. RM. EXHAUST FAN STARTER	QC91-20/13	1	
111	M45	浴室抽风机 A.C. RM. EXHAUST FAN	3φ 380V 0.25kW	1	
110	44ST	厕所风机起动箱 WC FAN STARTER	QC91-20/13	1	
109	M44	厕所抽风机 WC EXHAUST FAN	3φ 380V 0.25kW	1	
108	43ST	CO2室抽风机起动箱 CO2 RM. FAN STARTER	QC91-20/13	1	
107	M43	CO2室抽风机 CO2 RM. FAN	3φ 380V 0.75kW	1	
106	42ST	船员舱送风机起动箱 FOAM RM. FAN STARTER	QC91-20/13	1	
105	M42	船员舱送风机 FOAM RM. FAN	3φ 380V 1.5kW	1	
104	41ST	厨房送风机起动箱 GALLEY BLOW FAN STARTER	QC91-20/13	1	
103	M41	厨房送风机 GALLEY BLOW FAN	3φ 380V 0.25kW	1	
旧底图登记号					
底图登记号	序号	代 号	名 称 及 型 号	数 量	备 注
	NO.	STANDARD OR DRAWING NO.	NAME & TYPE	QTY.	REMARKS

136	M74	热水循环泵 H.W. CIRCULATING PUMP	3φ 380V 7.5kW	1	
135	74ST	热水循环泵起动箱 H.W. CIRCULATING PUMP STARTER	QC91-20/13	1	
134	M59	饮用淡水泵 D.F.W. PUMP	3φ 380V 2.2kW	1	
133	59ST	饮用淡水泵起动箱 D.F.W. PUMP STARTER	QC91-20/13	1	
132	58ST	日用淡水泵起动箱 DAILY F.W. PUMP STARTER		1	设备配套 SUPPLIED WITH SYS.
131	1-2M58	日用淡水泵 DAILY F.W. PUMP	3φ 380V 2.2kW	2	
130	57ST	日用海水泵起动箱 DAILY S.W. PUMP STARTER		1	设备配套 SUPPLIED WITH SYS.
129	1-2M57	日用海水泵 DAILY S.W. PUMP	3φ 380V 2.2kW	2	
128	M53~56	WC风机 WC FAN	3φ 380V	5	
127		水密开关 WATERTIGHT SWITCH		5	
126	52ST	船员舱送风机起动箱 FOAM RM. FAN STARTER	QC91-20/13	1	
125	M52	船员舱送风机 FOAM RM. FAN	3φ 380V 3kW	1	
124	51ST	船员舱送风机起动箱 FOAM RM. FAN STARTER	QC91-20/13	1	
123	M51	船员舱送风机 FOAM RM. FAN	3φ 380V 1.5kW	1	
122	50ST、50AST	更衣间抽风机起动箱 CHANGING ROOM EXHAUST FAN STARTER	QC91-20/13	2	
121	M50、M50A	更衣间抽风机 CHANGING ROOM EXHAUST FAN	3φ 380V 0.25kW	2	
120	49ST	洗衣间起动箱 WASHING RM. EXHAUST FAN STARTER	QC91-20/13	1	
旧底图登记号					
底图登记号	序号	代 号	名 称 及 型 号	数 量	备 注
	NO.	STANDARD OR DRAWING NO.	NAME & TYPE	QTY.	REMARKS

152	MCCP	箱侧推中央控制箱 MAIN CONTROL BOX OF BOW THRUSTRE MOTER	1		
151	FTM	箱侧推电动机 3φ 380V 50Hz 200kW BOW THRUSTRE MOTER	1		
150	1-43EH	电暖器 AC220V 1KW ELECTRIC HEATER	43		
149		舱室带开关插座 250V 10A CABIN WITH SWITCH SOCKET	43		
148	~PS~	压力开关 PRESSURE SWITCH	6		
147	~RC~	遥控按钮 LAS/J-2-1D REMOTE BUTTON	4		
146	1-2MO	微波炉 1φ 220V 1kW MICRO-WAVE OVEN	2		
145	1~2DRC	电饭煲 1φ 220V 2kW ELECTRIC COOKER	2		
144	REF	冰柜 1φ 220V 1kW REFRIGERATOR	1		
143	1~2WM	洗衣机 1φ 220V 1.5kW WASHING MACHINE	2		
142		防水开关插座 220V 10A SOCKET WITH SWITCH WATER PROOF	8		
141		防水开关插座 380V 32A SOCKET WITH SWITCH WATER PROOF	3		
140	76ST	日用舱底泵起动机 QC91-20/13 DAILY SERVICE BILGE PUMP STARTER	1		
139	M76	日用舱底泵 3φ 380V 2.2kW DAILY SERVICE BILGE PUMP	1		
138	STP	生活污水处理装置控制箱 QC91-20/13 ROPE STORE EXHAUST FAN STARTER	1		
137	HWT	电加热水柜 3φ 380V 18kW ELECTRIC H.W. TANK	1		
旧底图登记号					
底图登记号	序号	代 号	名 称 及 型 号	数 量	备 注
	NO.	STANDARD OR DRAWING NO.	NAME & TYPE	QTY.	REMARKS

148					
147					
146					
145					
144	RDC	无线电备用蓄电池组 RADIO BATTERY	每组6-CQ-200 2只 1		
143	1DC	蓄电池组 BATTERY SET	每组6-CQ-200 12只 1		
142	FI	艏侧推变频器 FREQUENCY TRANSFORMER OF BOW THRUSTRE MOTER	1		
141	BLS	液位开关 LEVEL SWITCH	1		
140	FIV	艏侧推变频启动器 FREQUENCY STARTER OF BOW THRUSTRE MOTER	1		
139	SCP2	右舷副控板 WING PANEL STARBOARD	1		
138	SCP1	左舷副控板 WING PANEL PORT	1		
137	MCP	艏侧推主控制板 MAIN PANEL OF BOW THRUSTRE MOTER	1		
旧底图登记号					
底图登记号	序号	代 号	名 称 及 型 号	数 量	备 注
	NO.	STANDARD OR DRAWING NO.	NAME & TYPE	QTY.	REMARKS

罗经甲板
COMPASS DECK

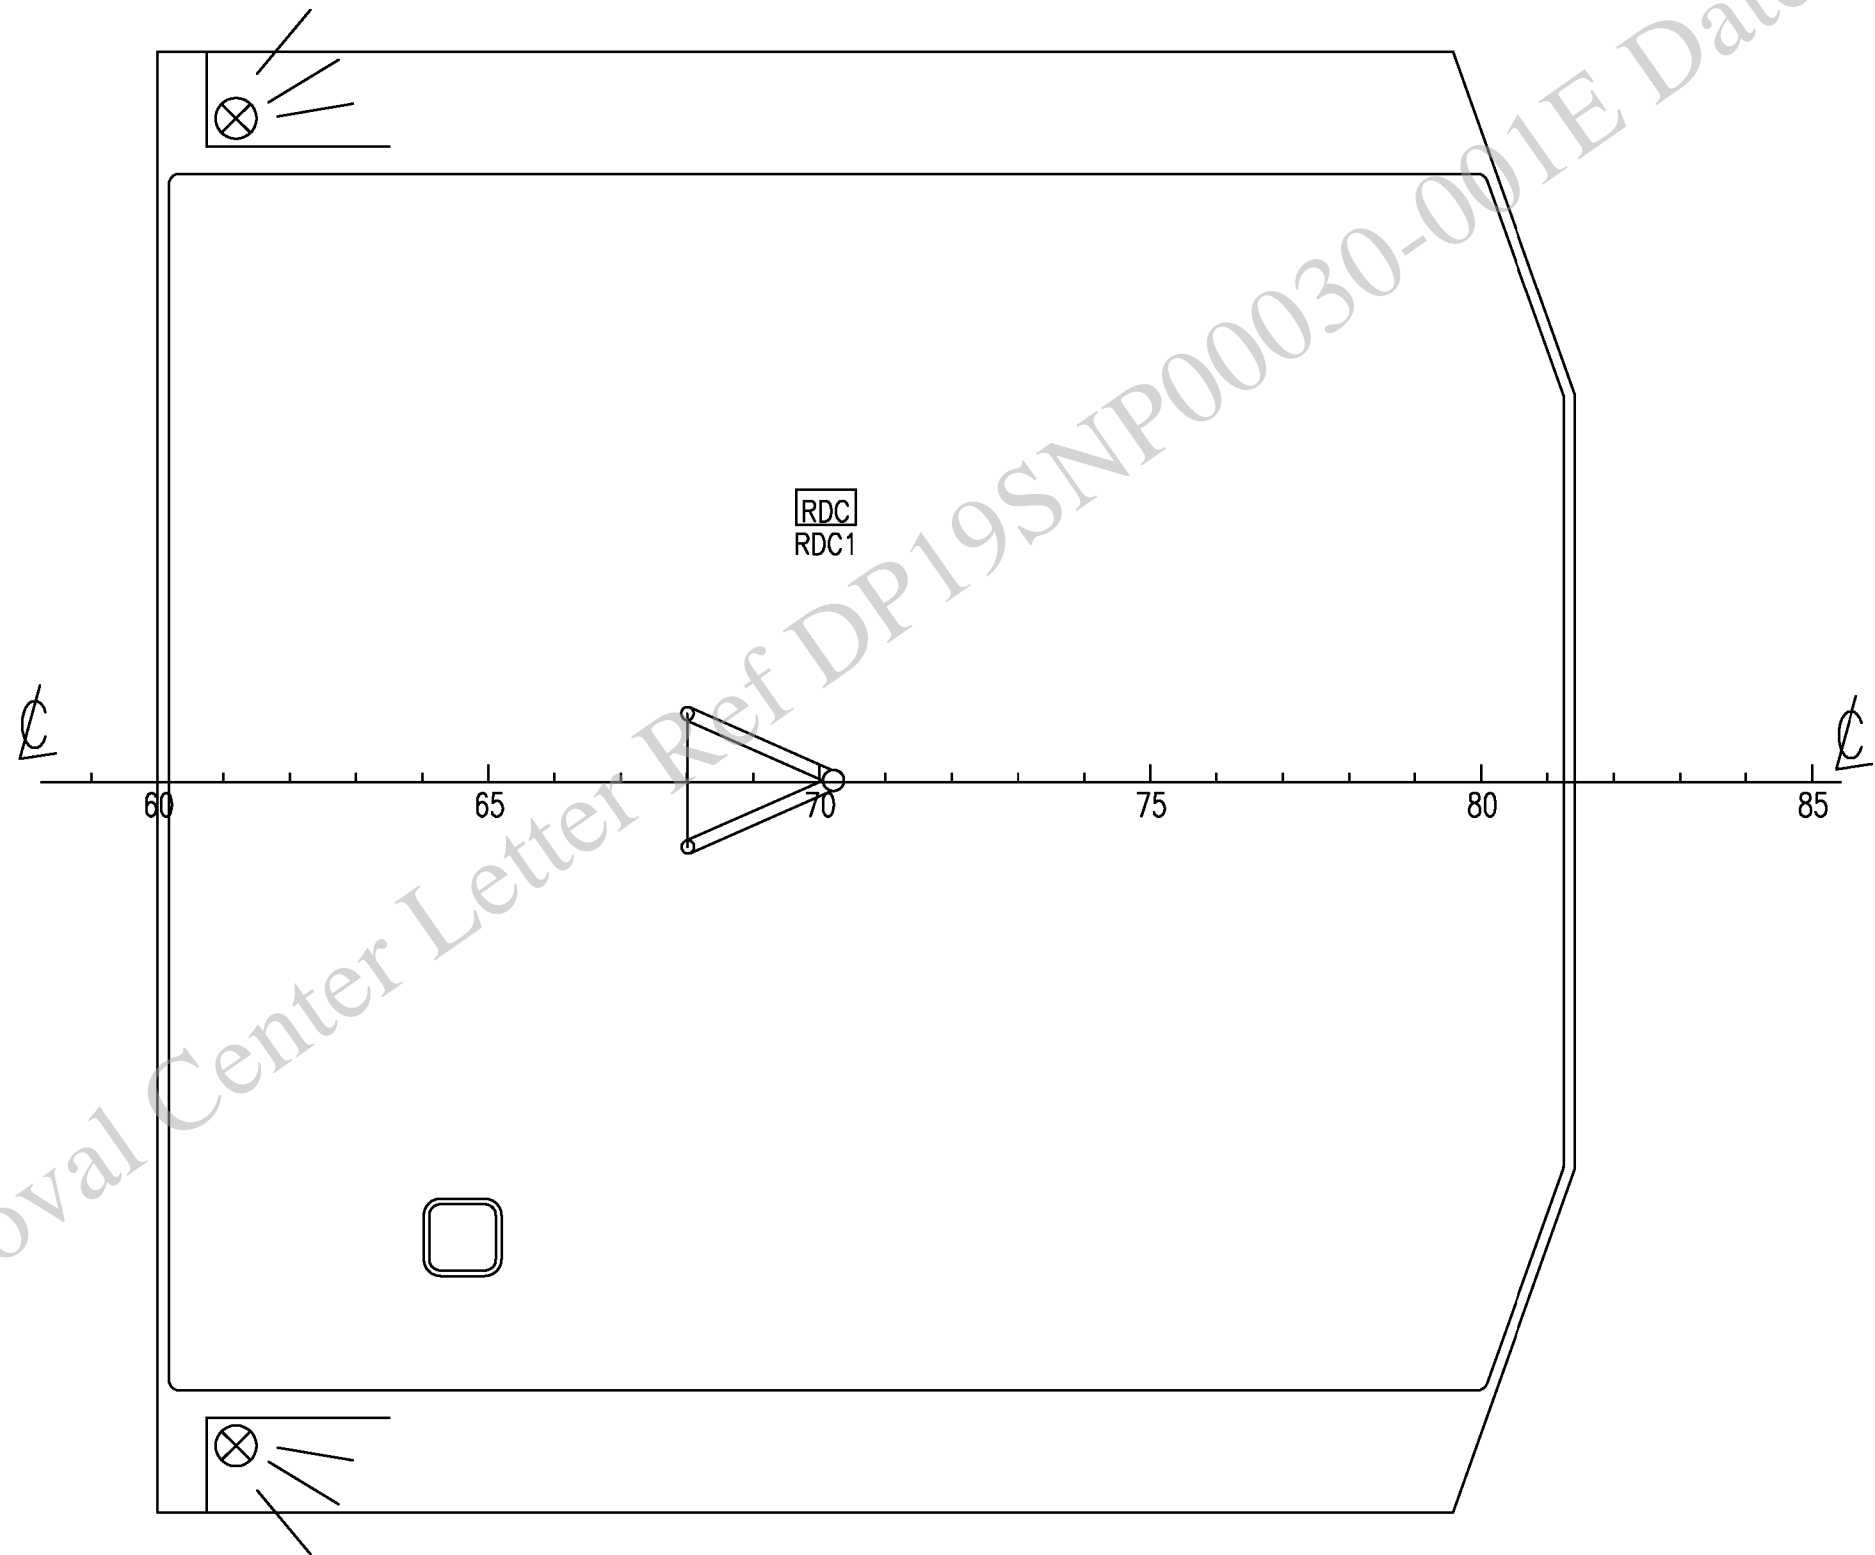


旧底图登记号

底图登记号

驾驶甲板
BRIDGE DECK


- MA5 MCP
- MA6 MCP
- MS712 FAP
- MS607-3 15RC2
- 1ES1 1EAP1
- 2ES1 2EAP1
- MS708 1HP
- MS709 2HP
- MS710 NLP
- MS711 SLP
- MS701 LD-1

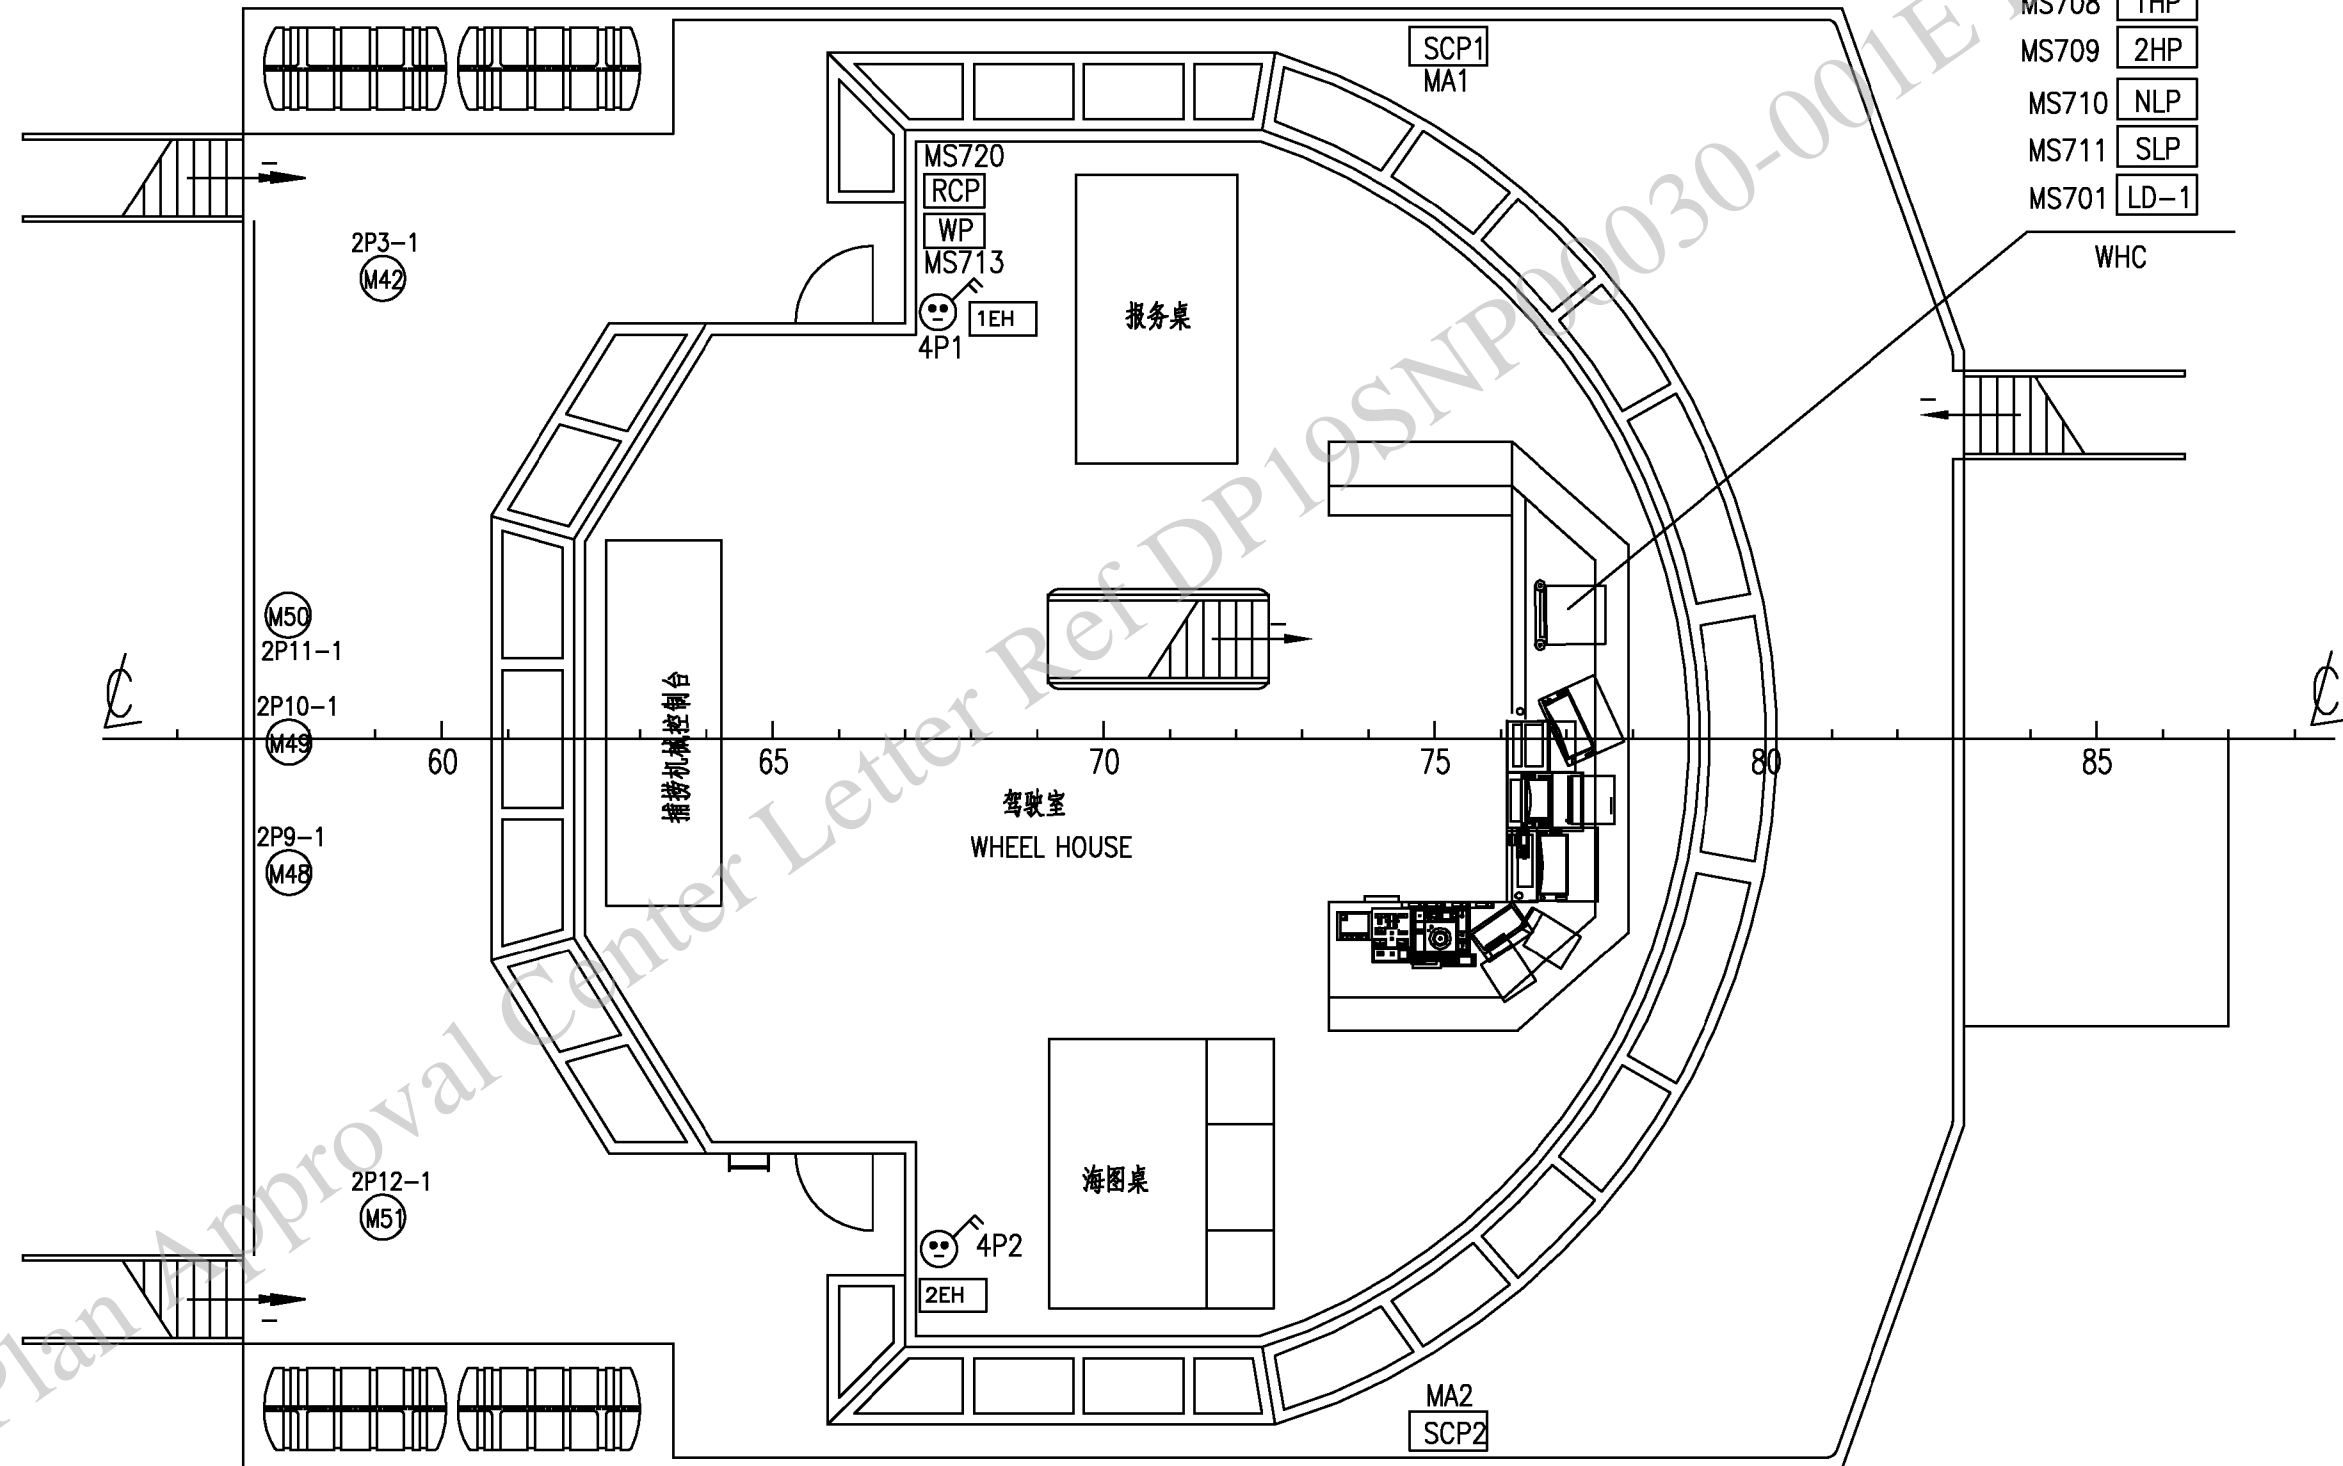

旧底图登记号


底图登记号

艏楼甲板
FORECASTLE DECK

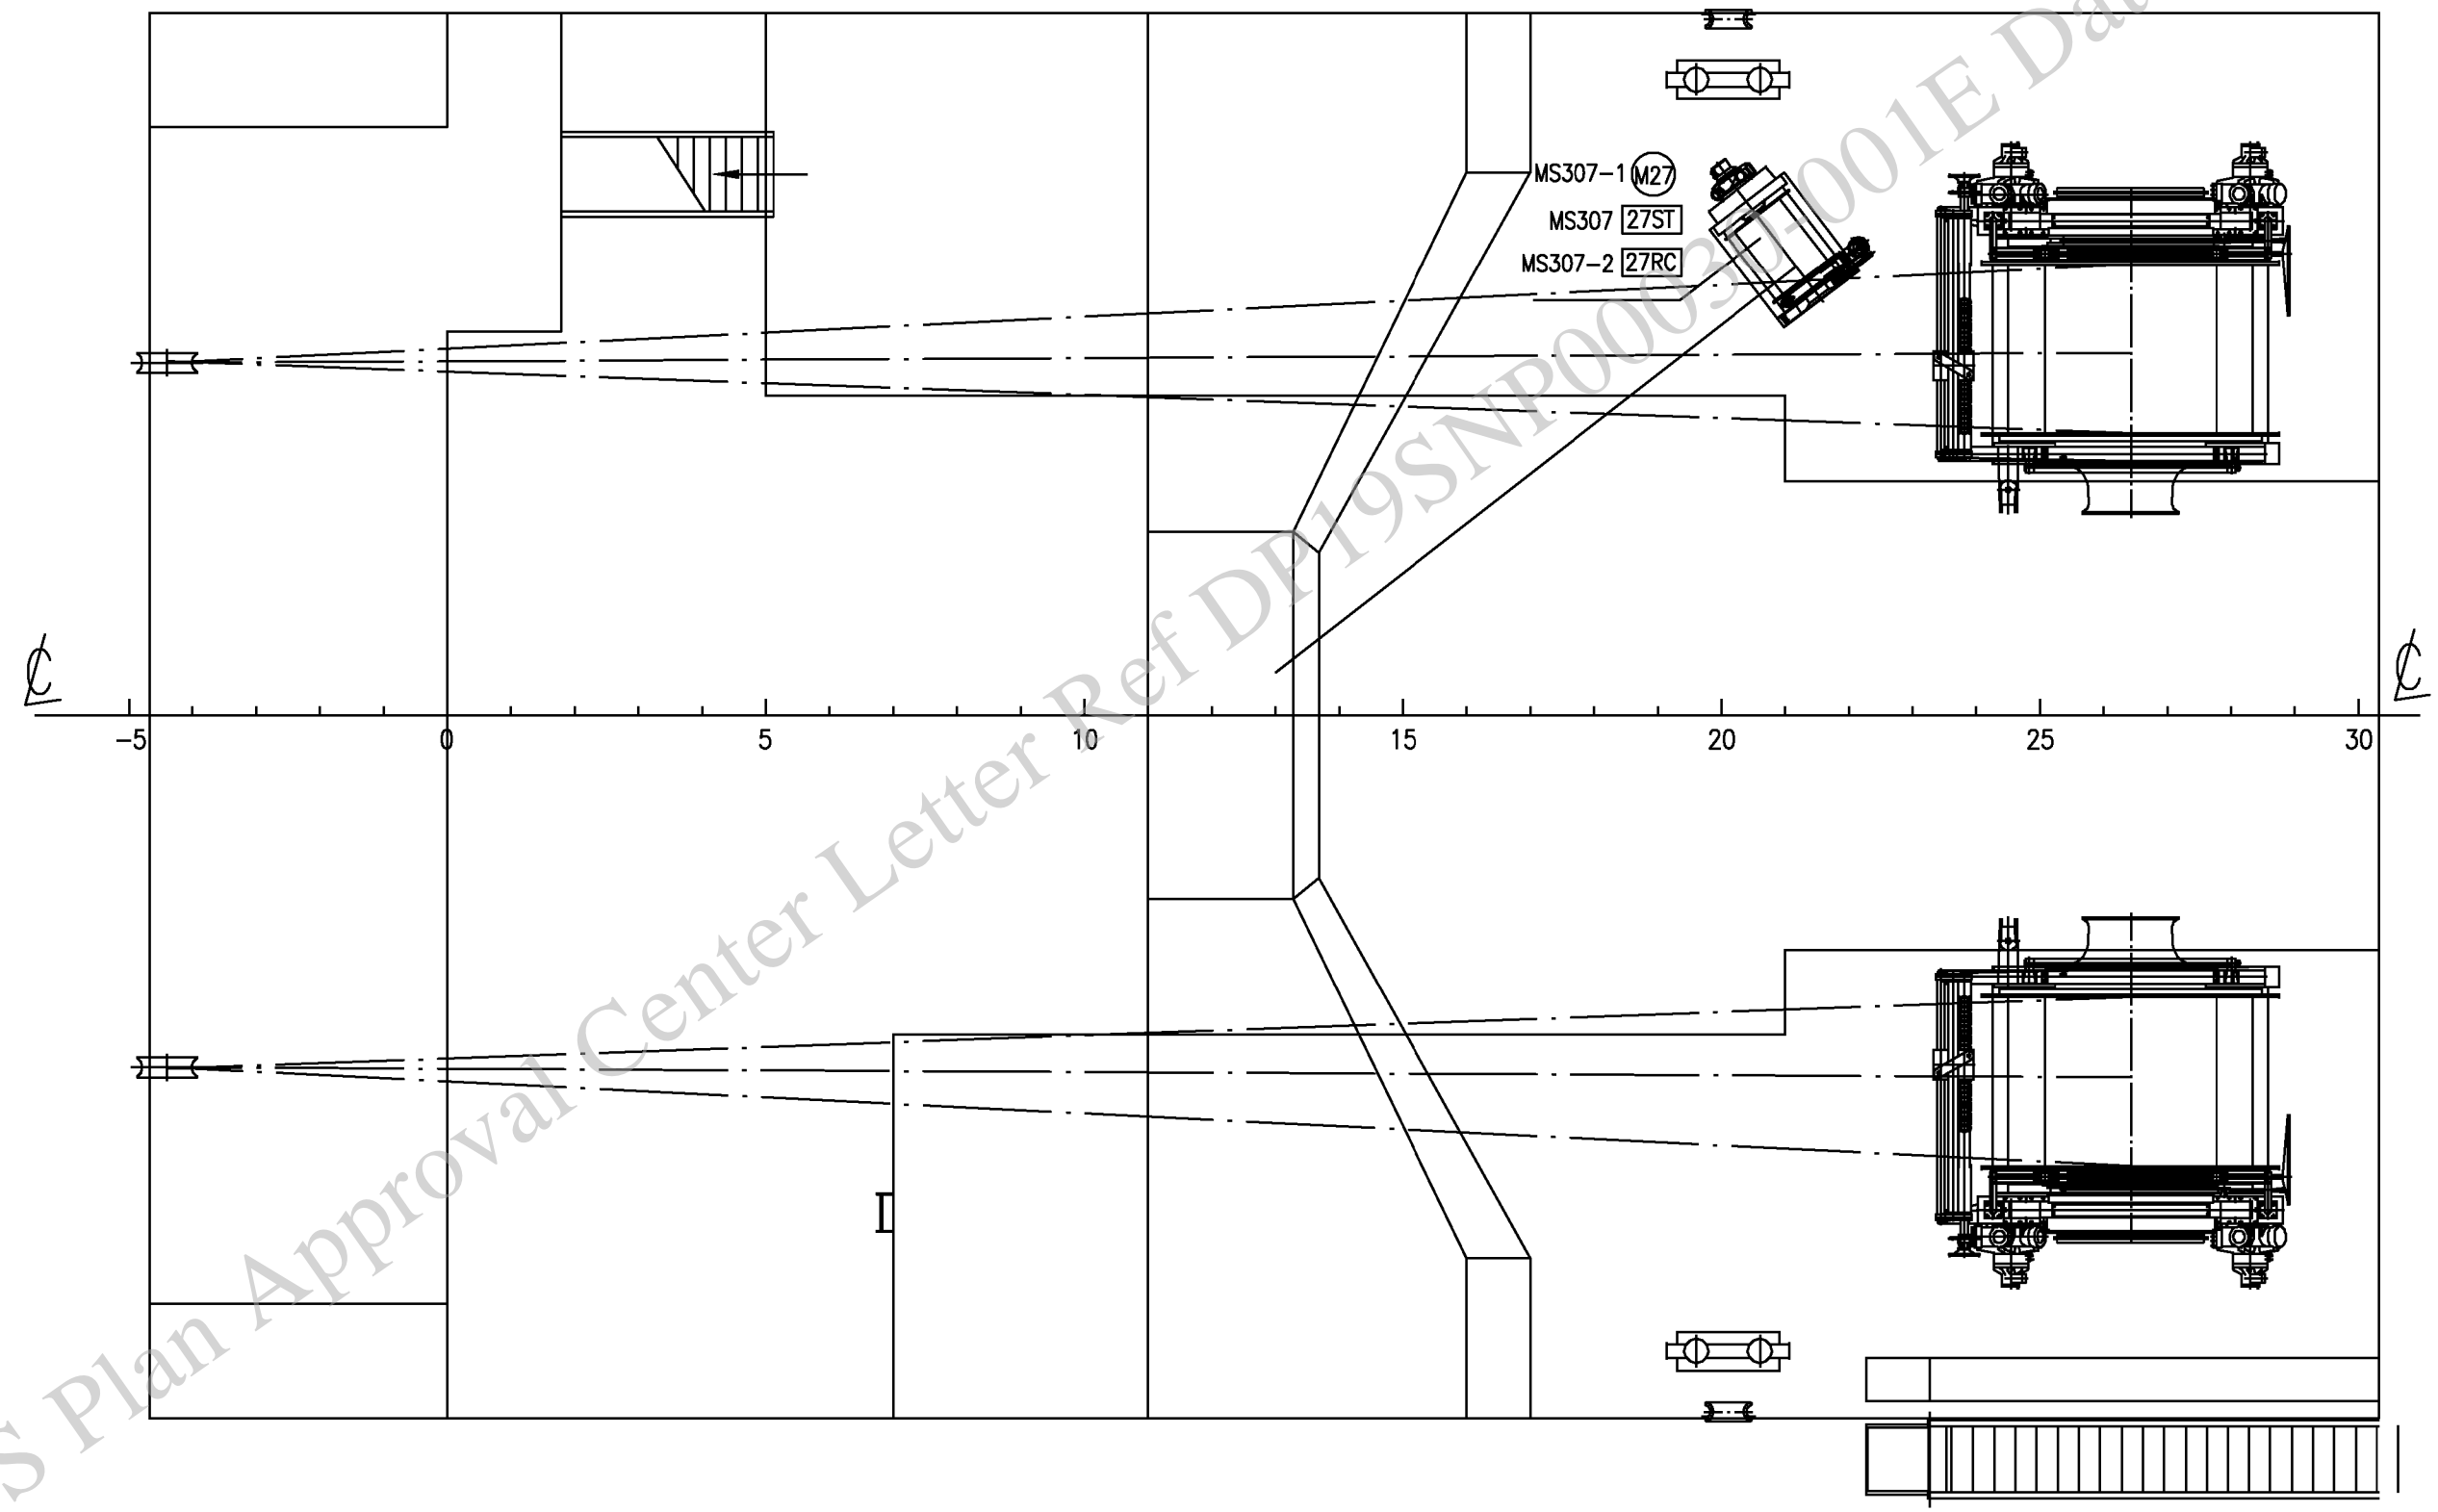

旧底图登记号
底图登记号


艏楼甲板
FORECASTLE DECK

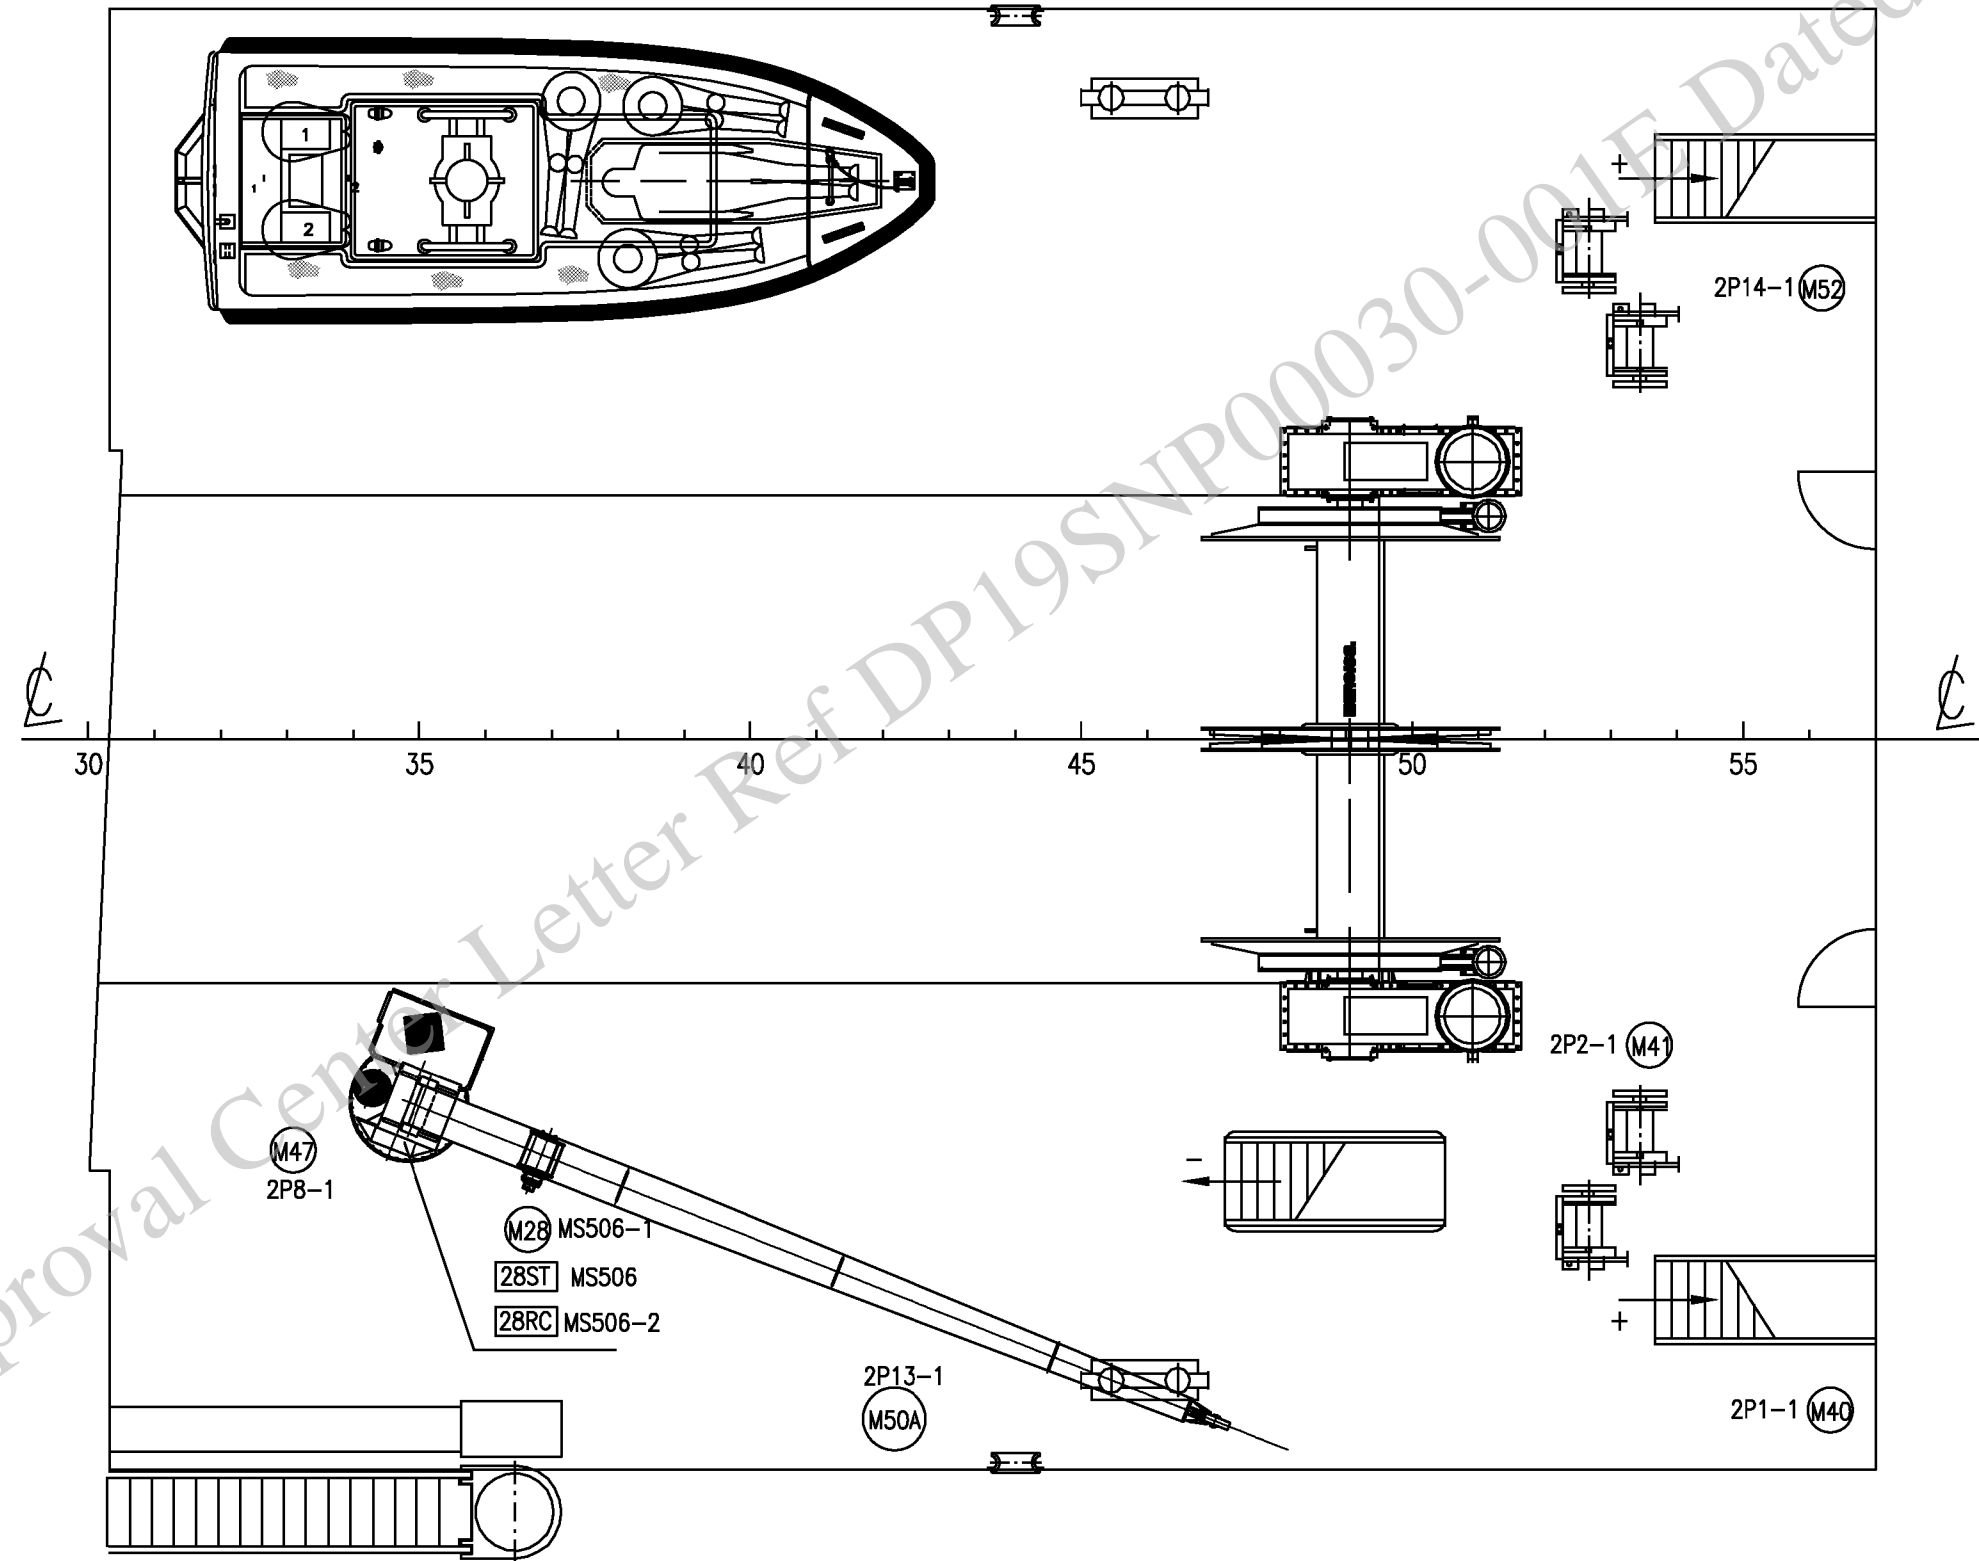

旧底图登记号

底图登记号


艏楼甲板
FORECASTLE DECK

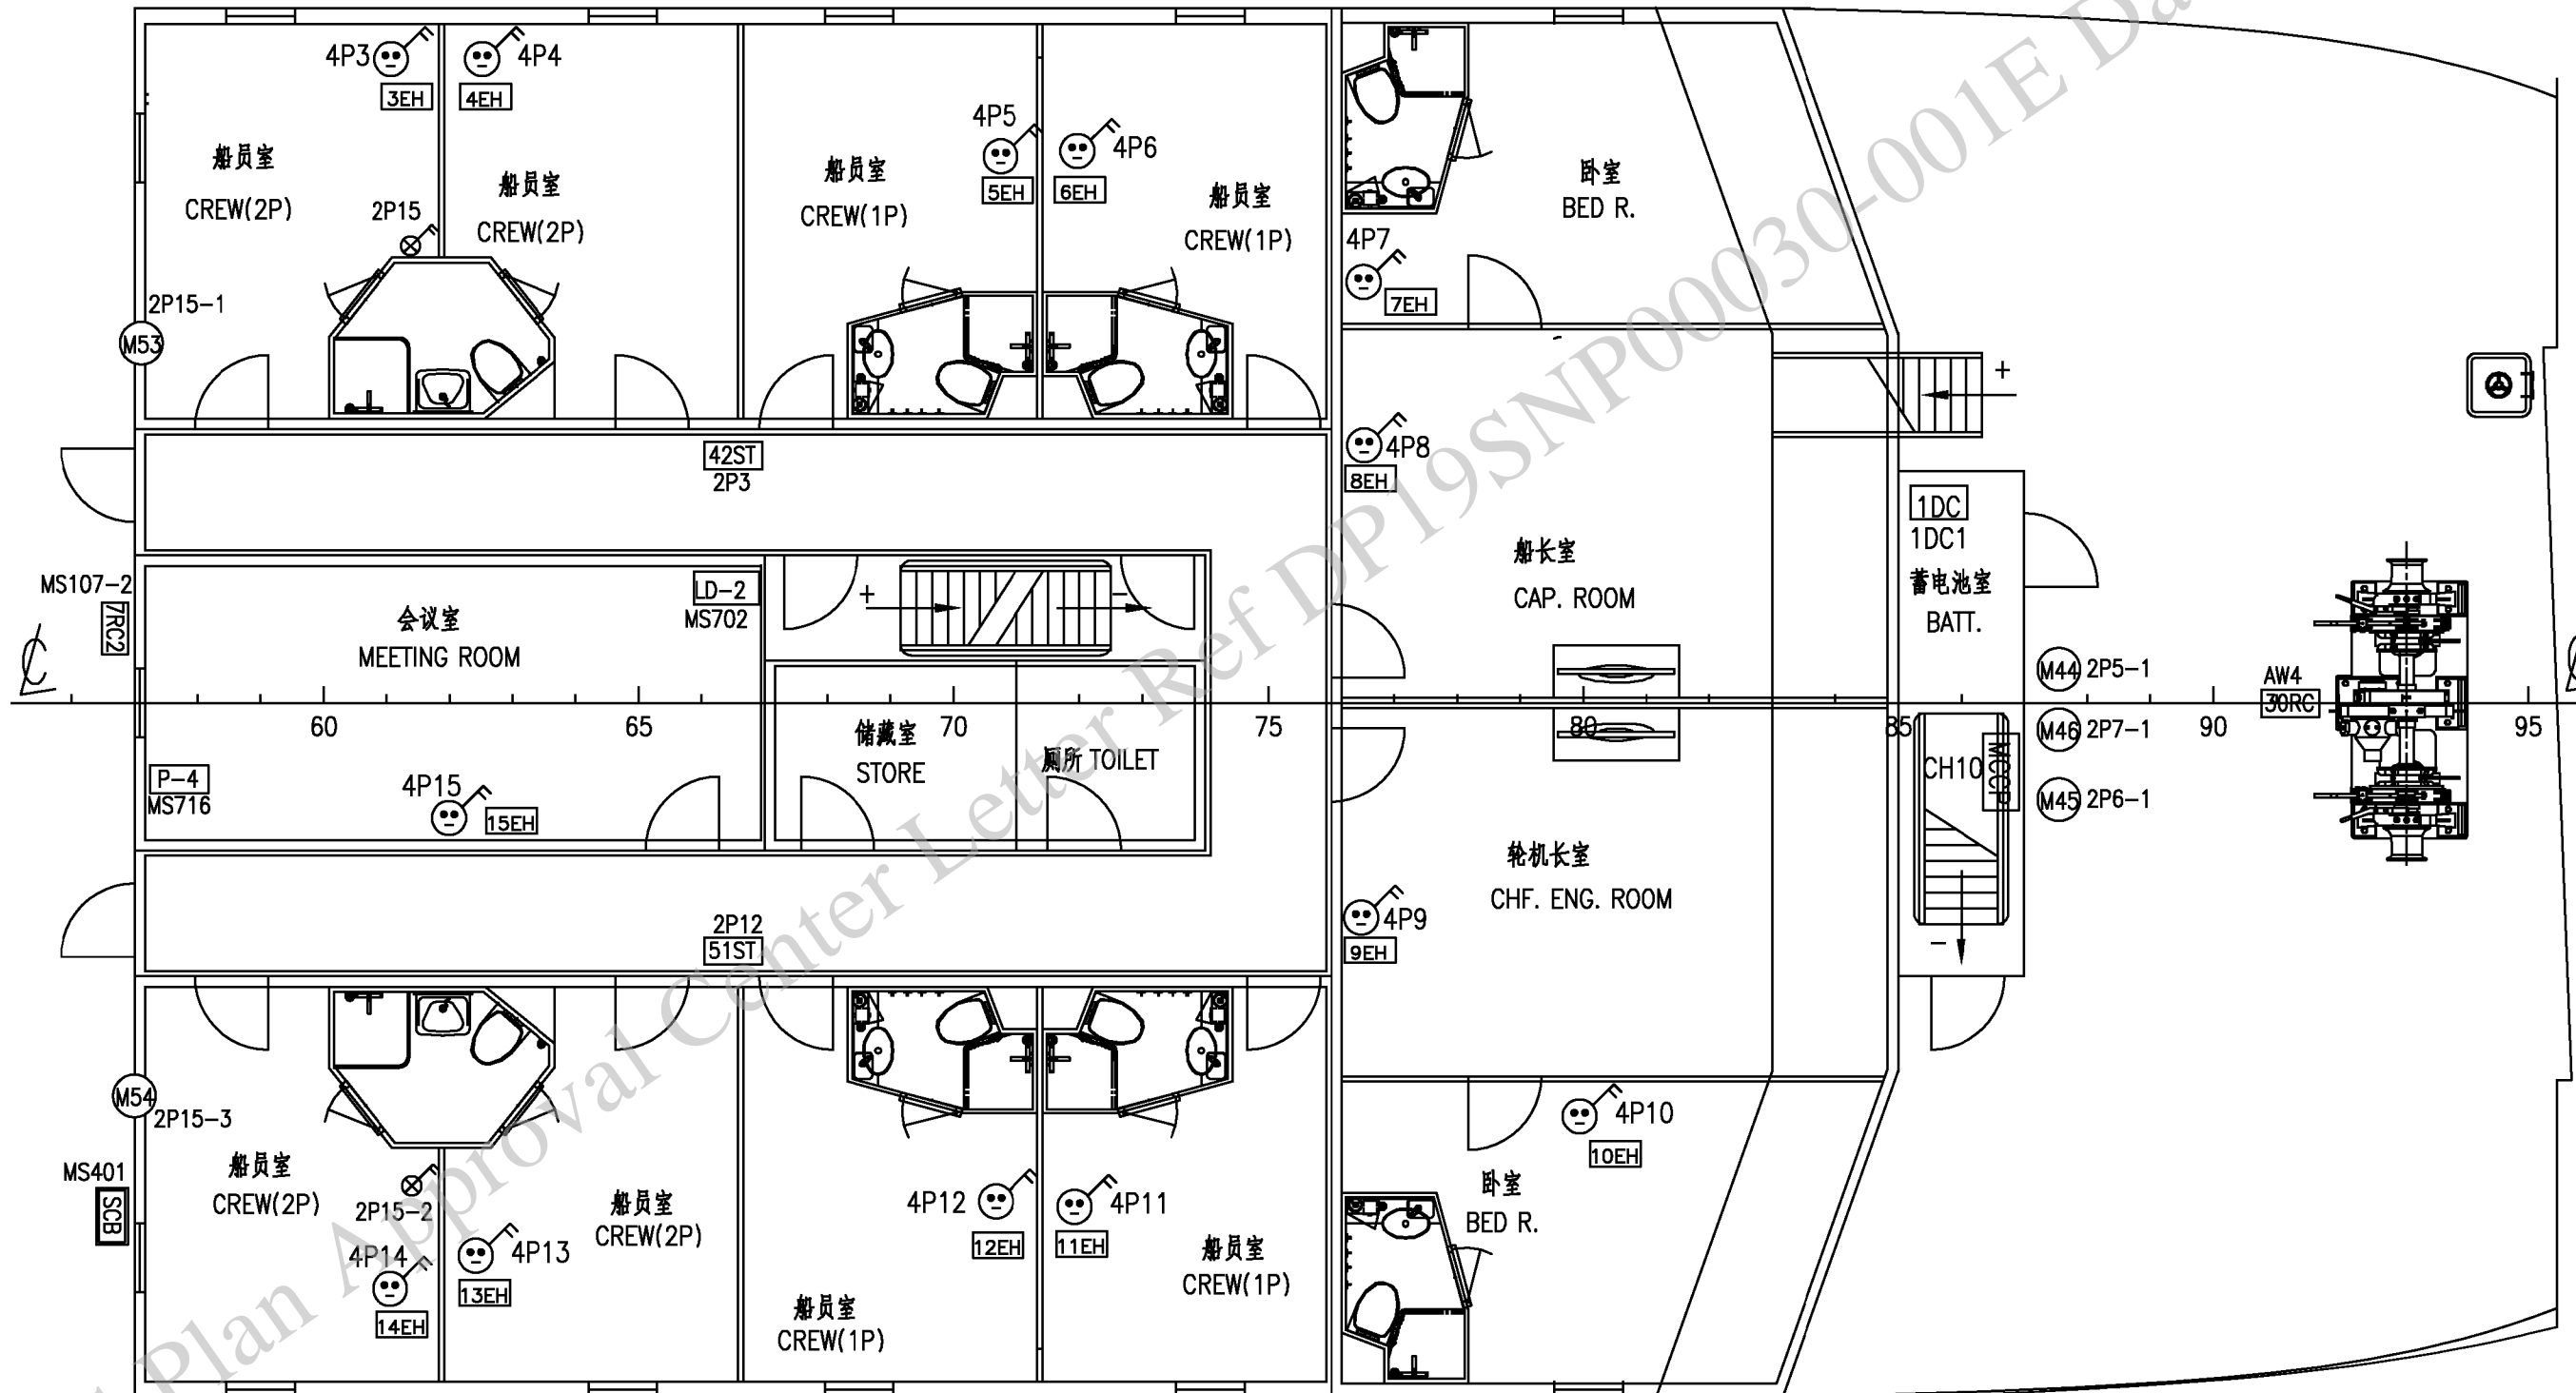

旧底图登记号

底图登记号


拖网甲板
TRAWL DECK

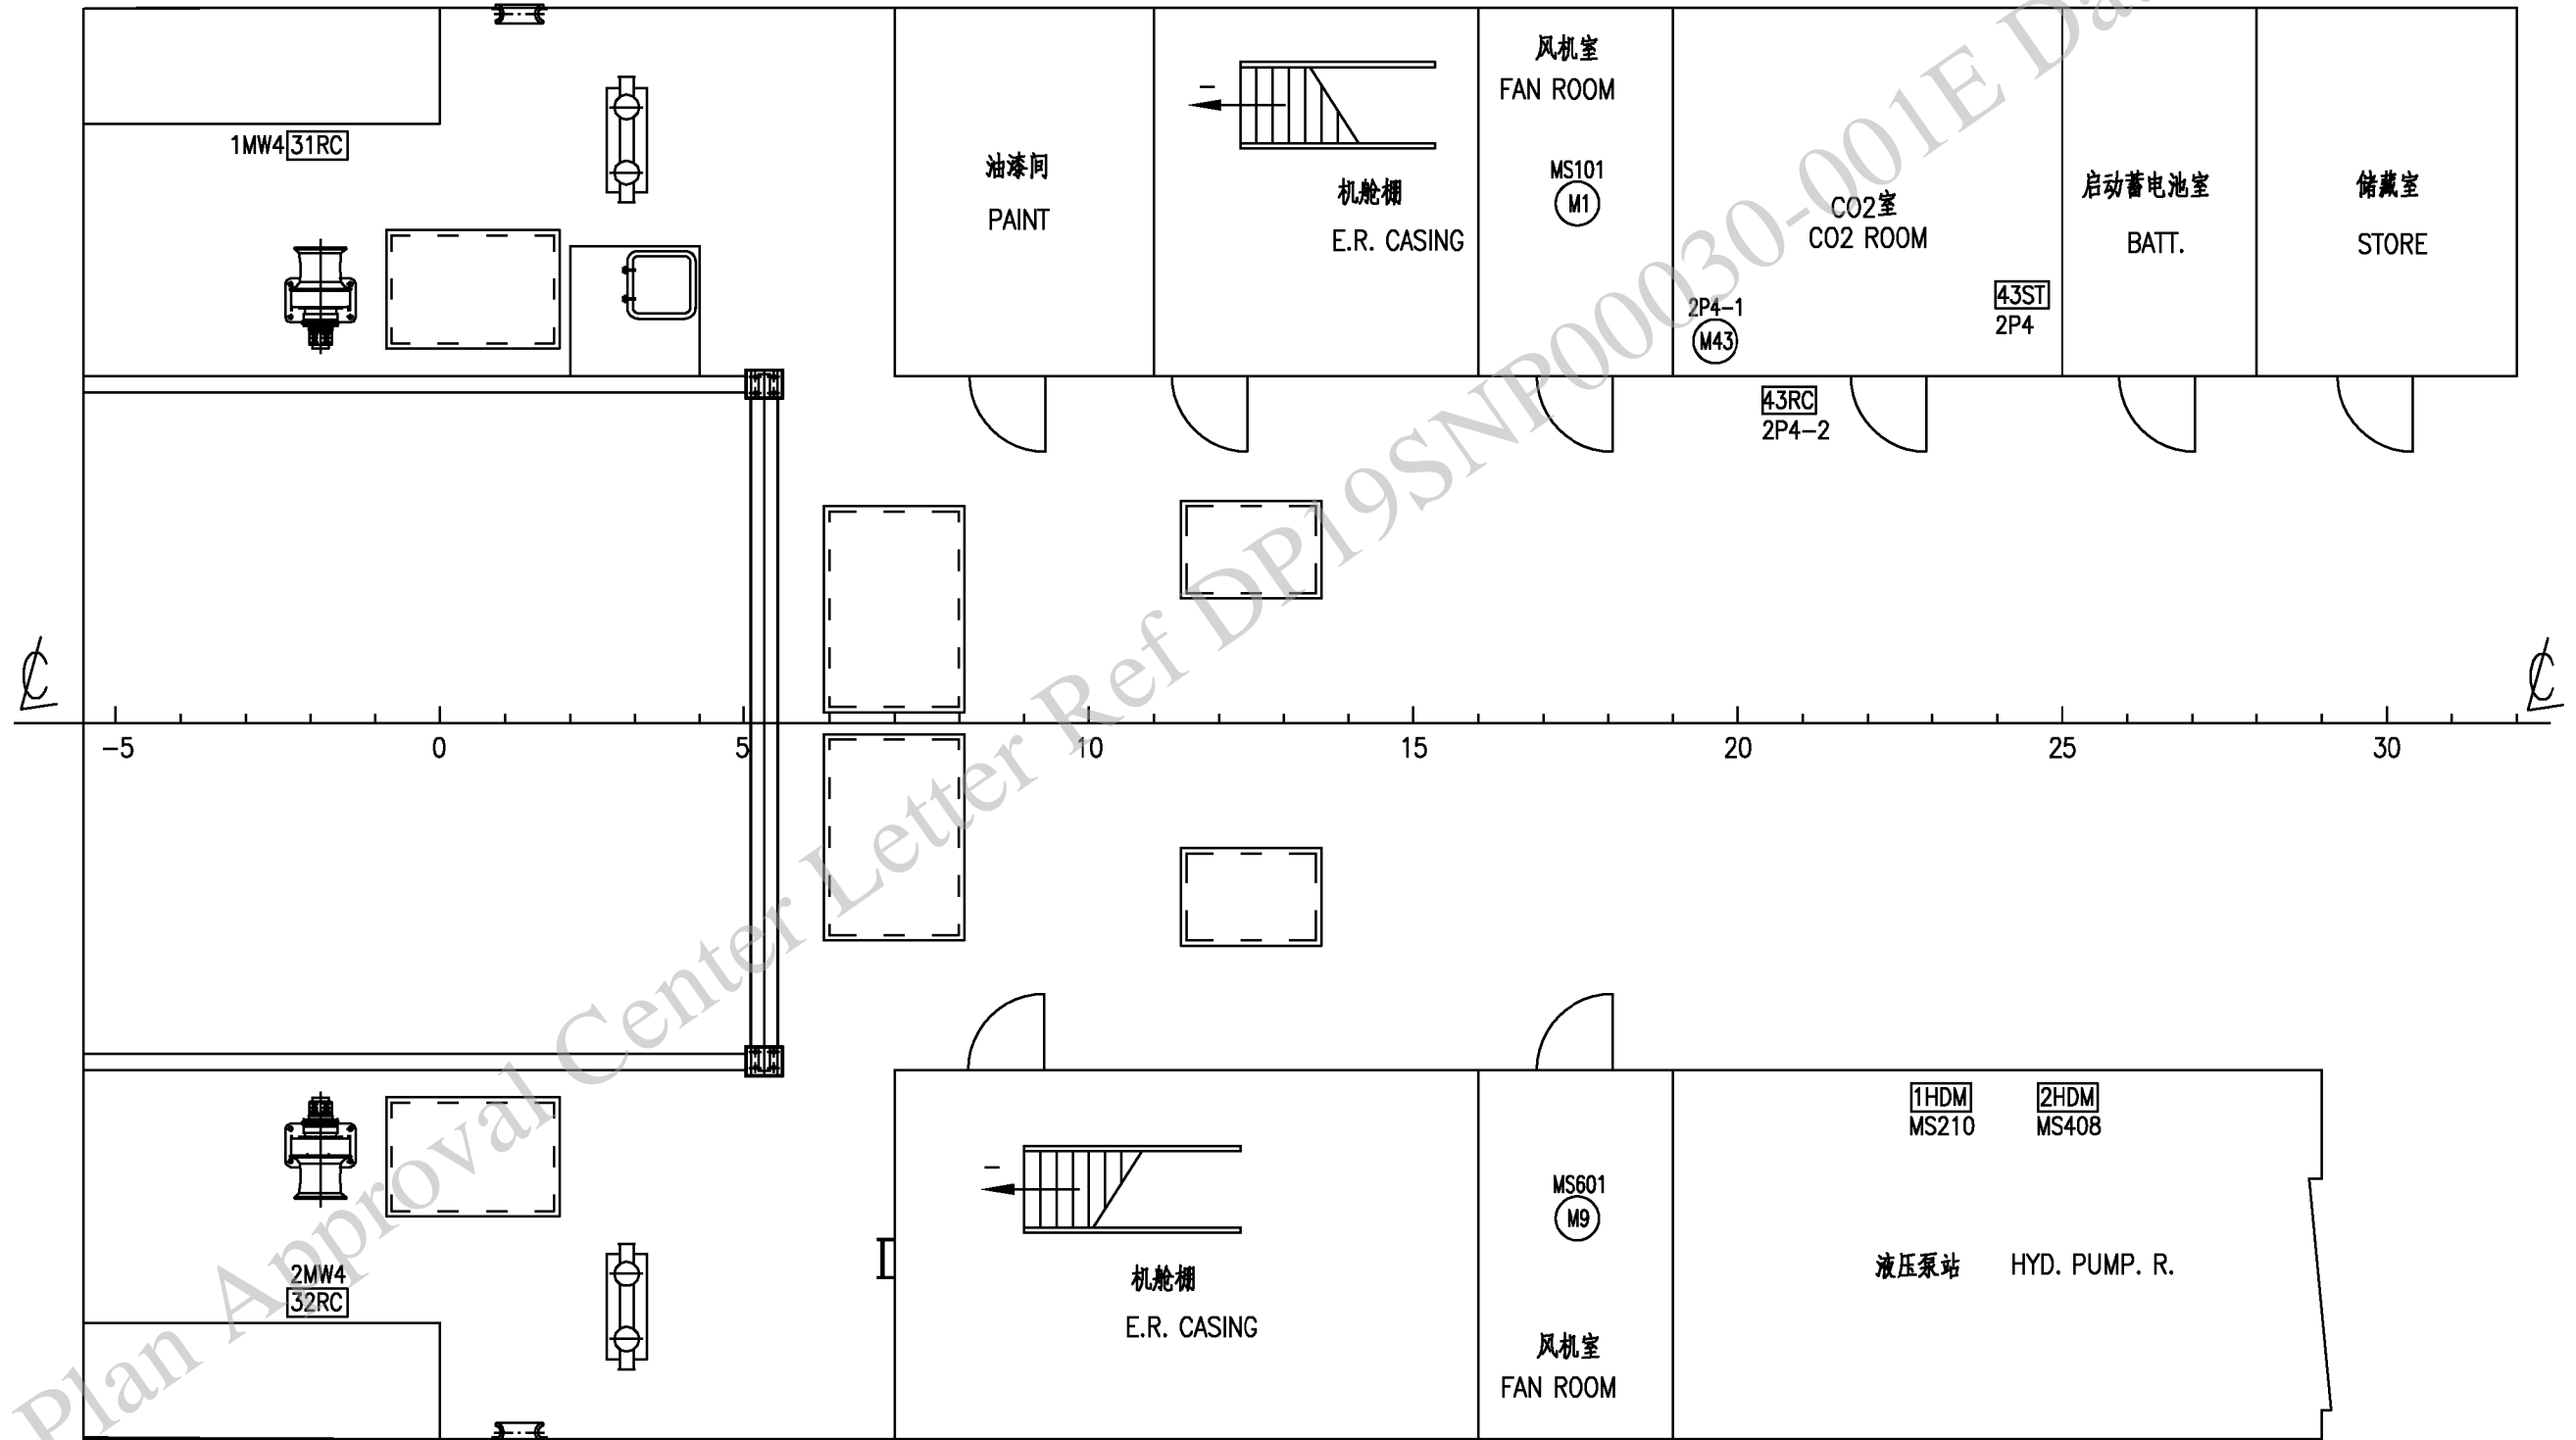

旧底图登记号


底图登记号

拖网甲板
TRAWL DECK

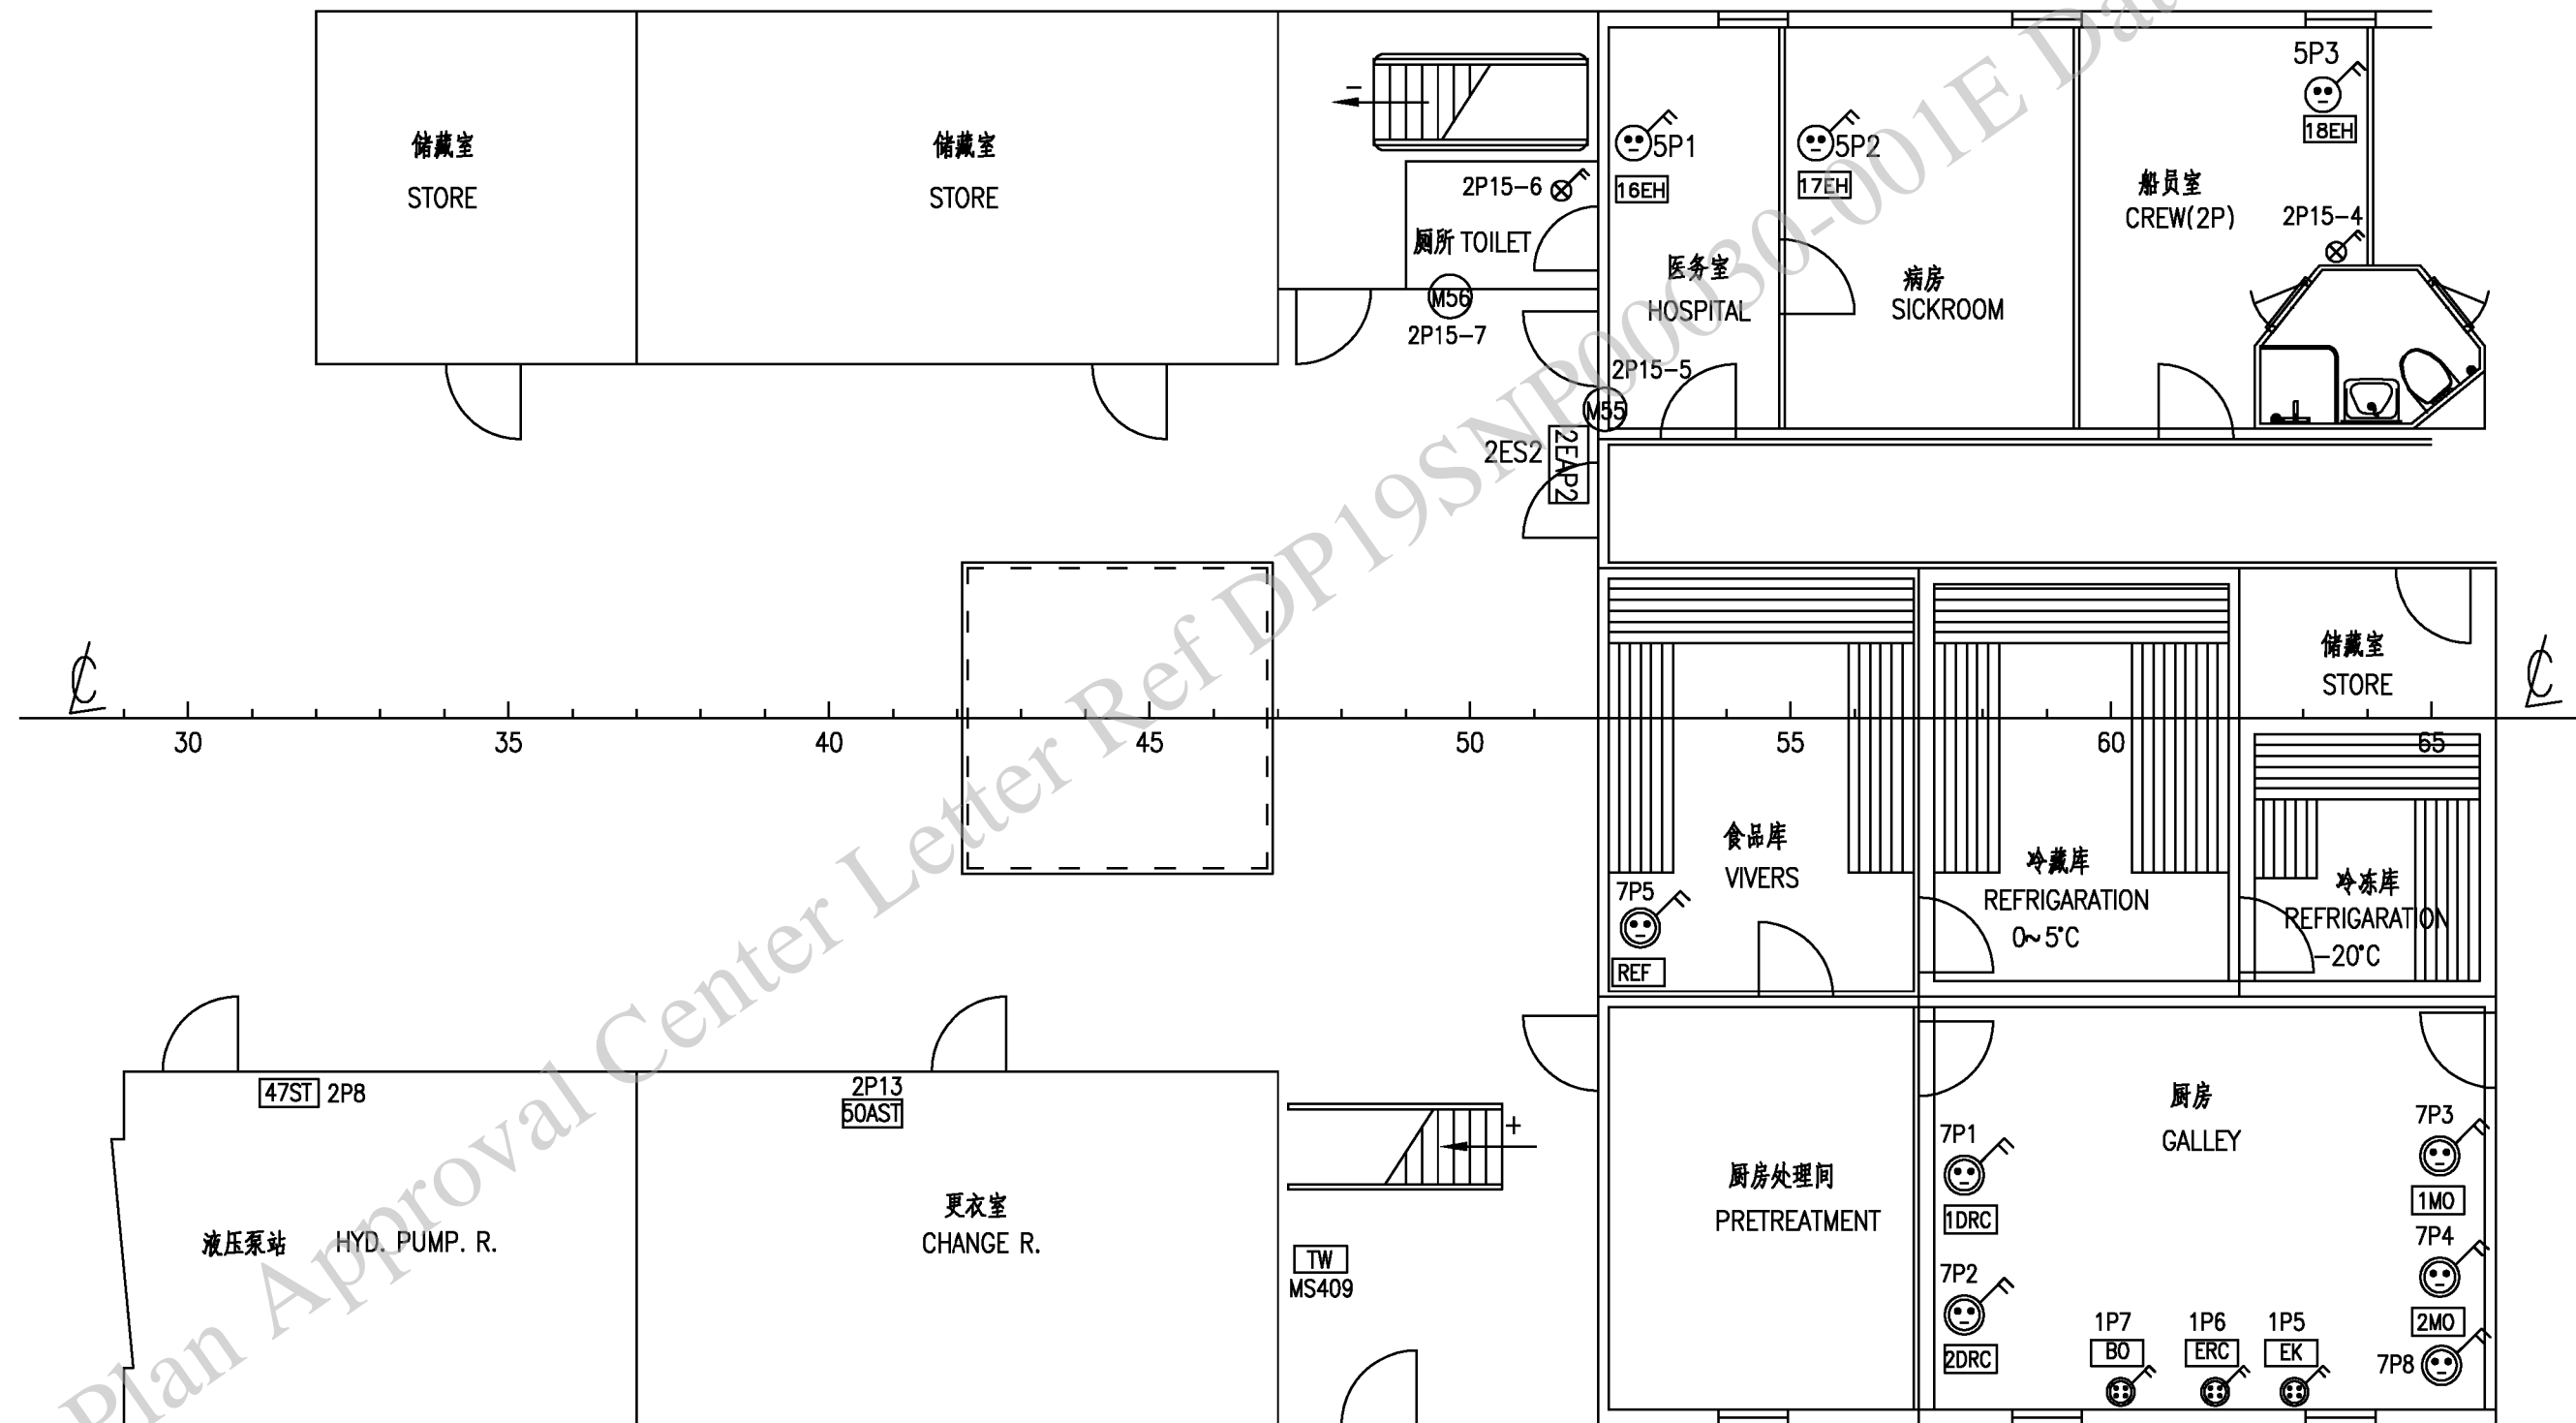

旧底图登记号
底图登记号


拖网甲板
TRAWL DECK

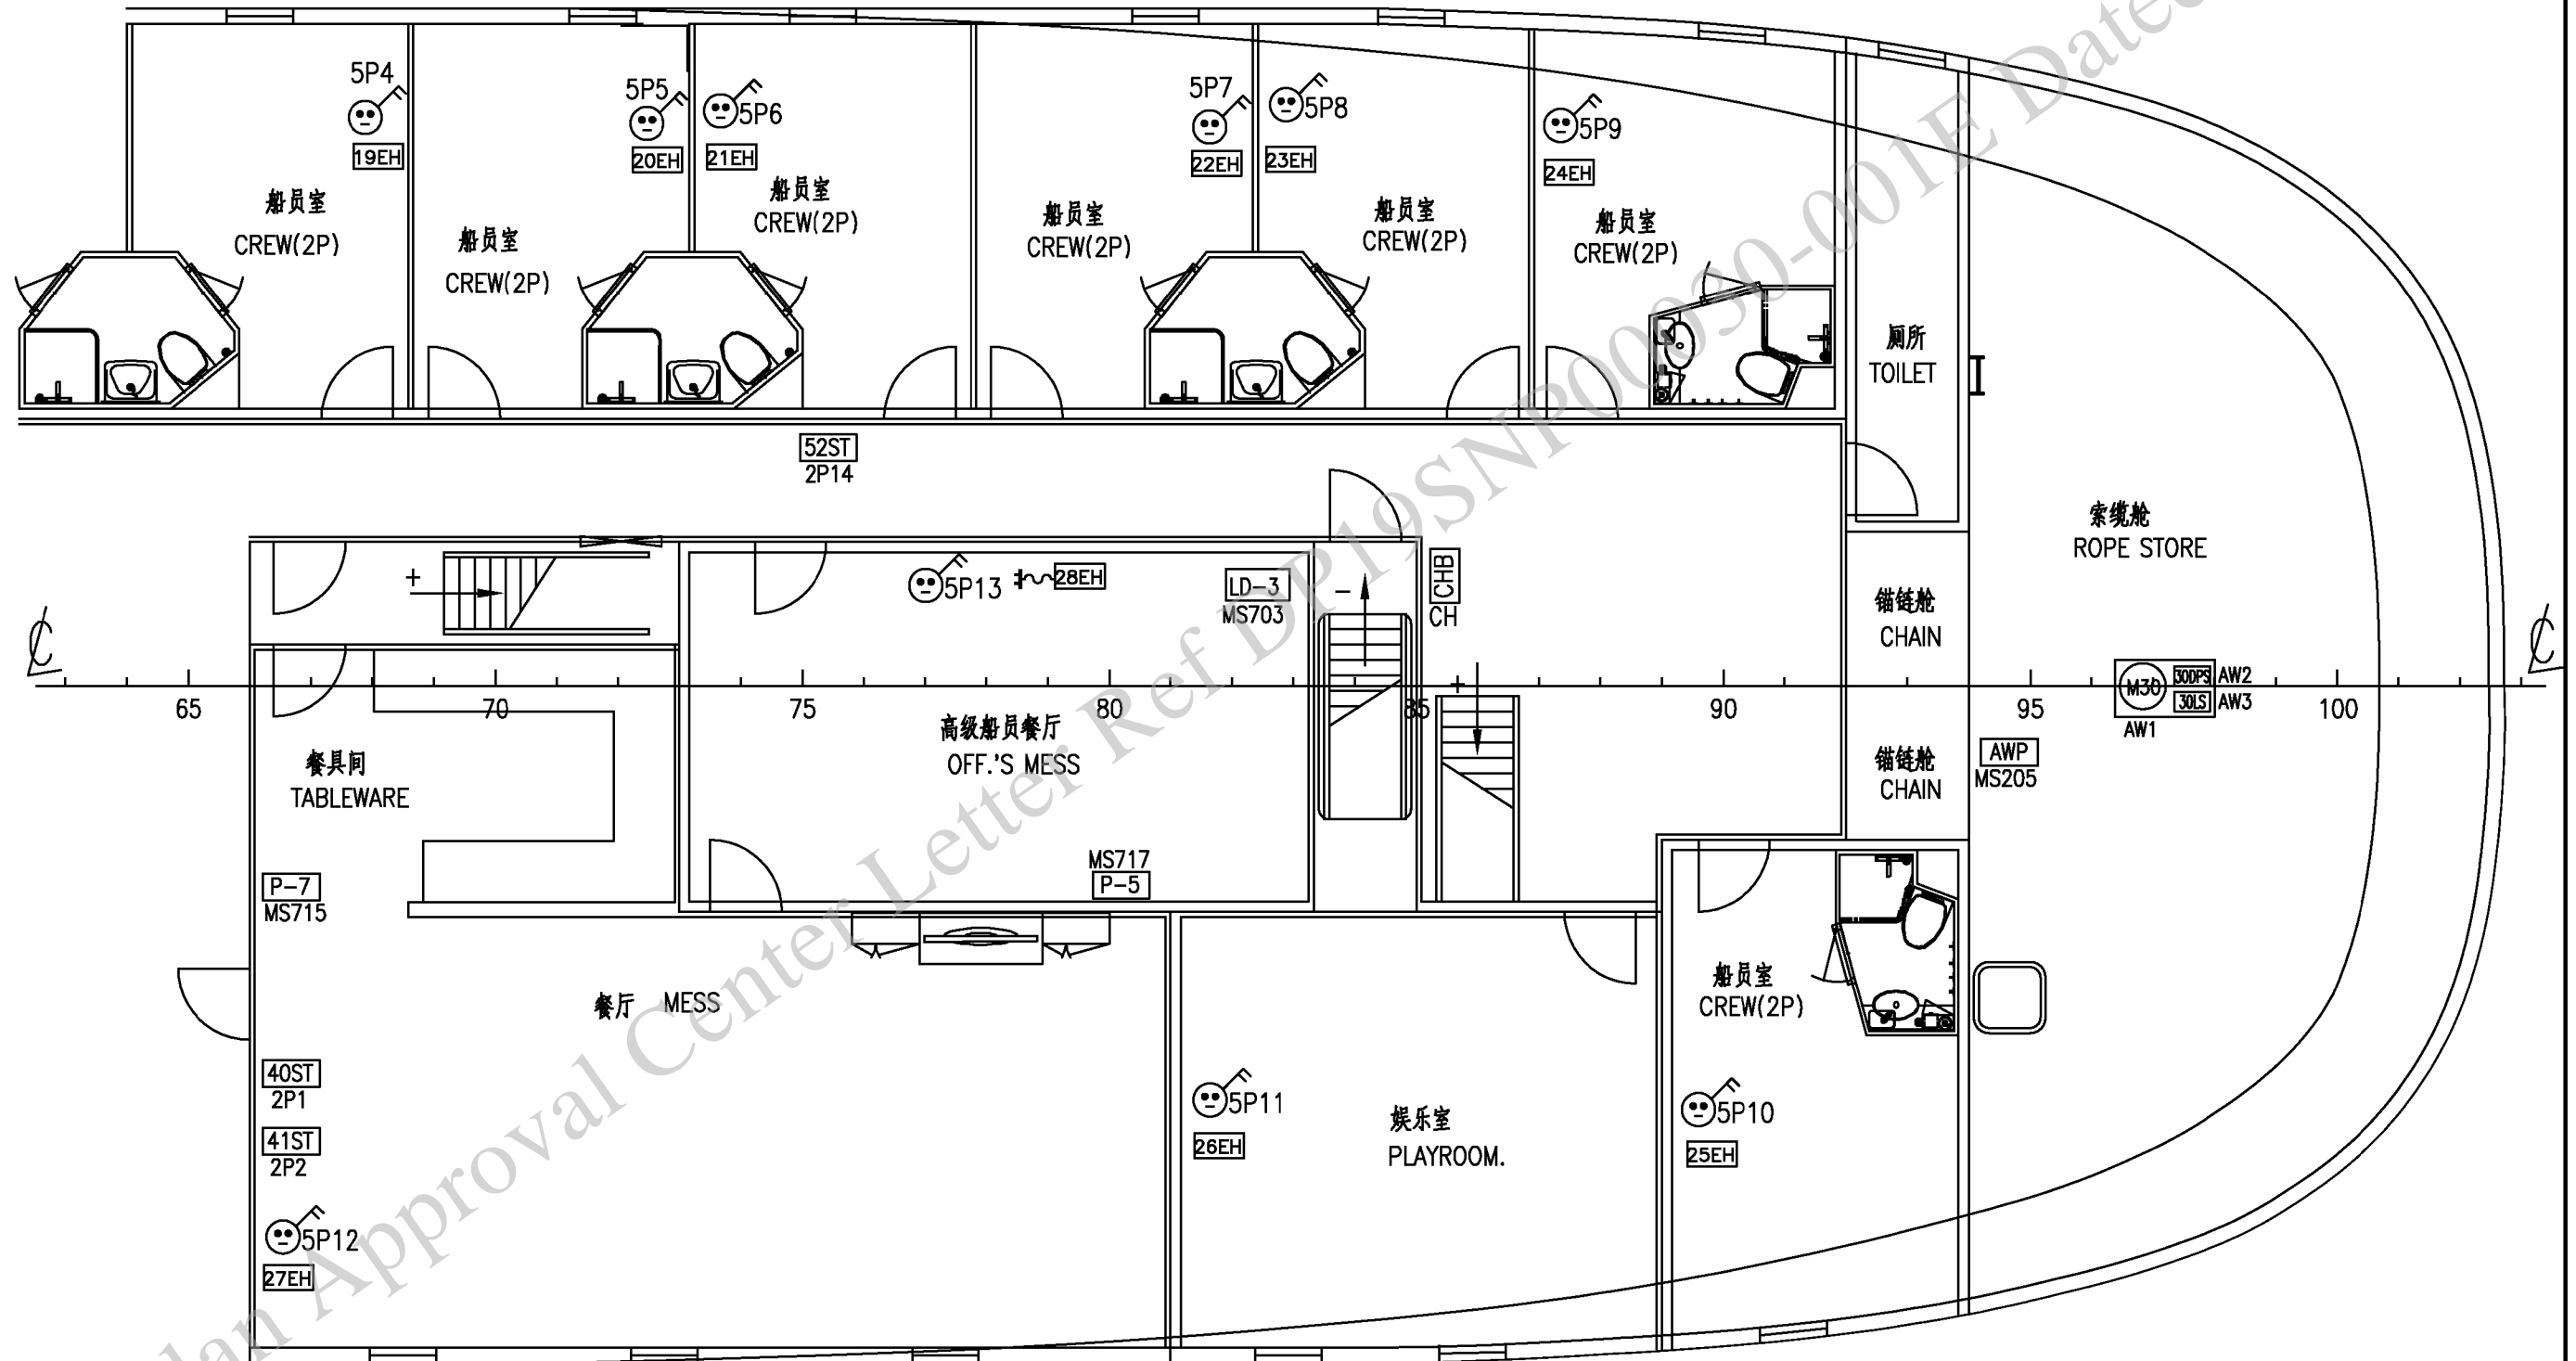

旧底图登记号

底图登记号


主甲板
MAIN DECK

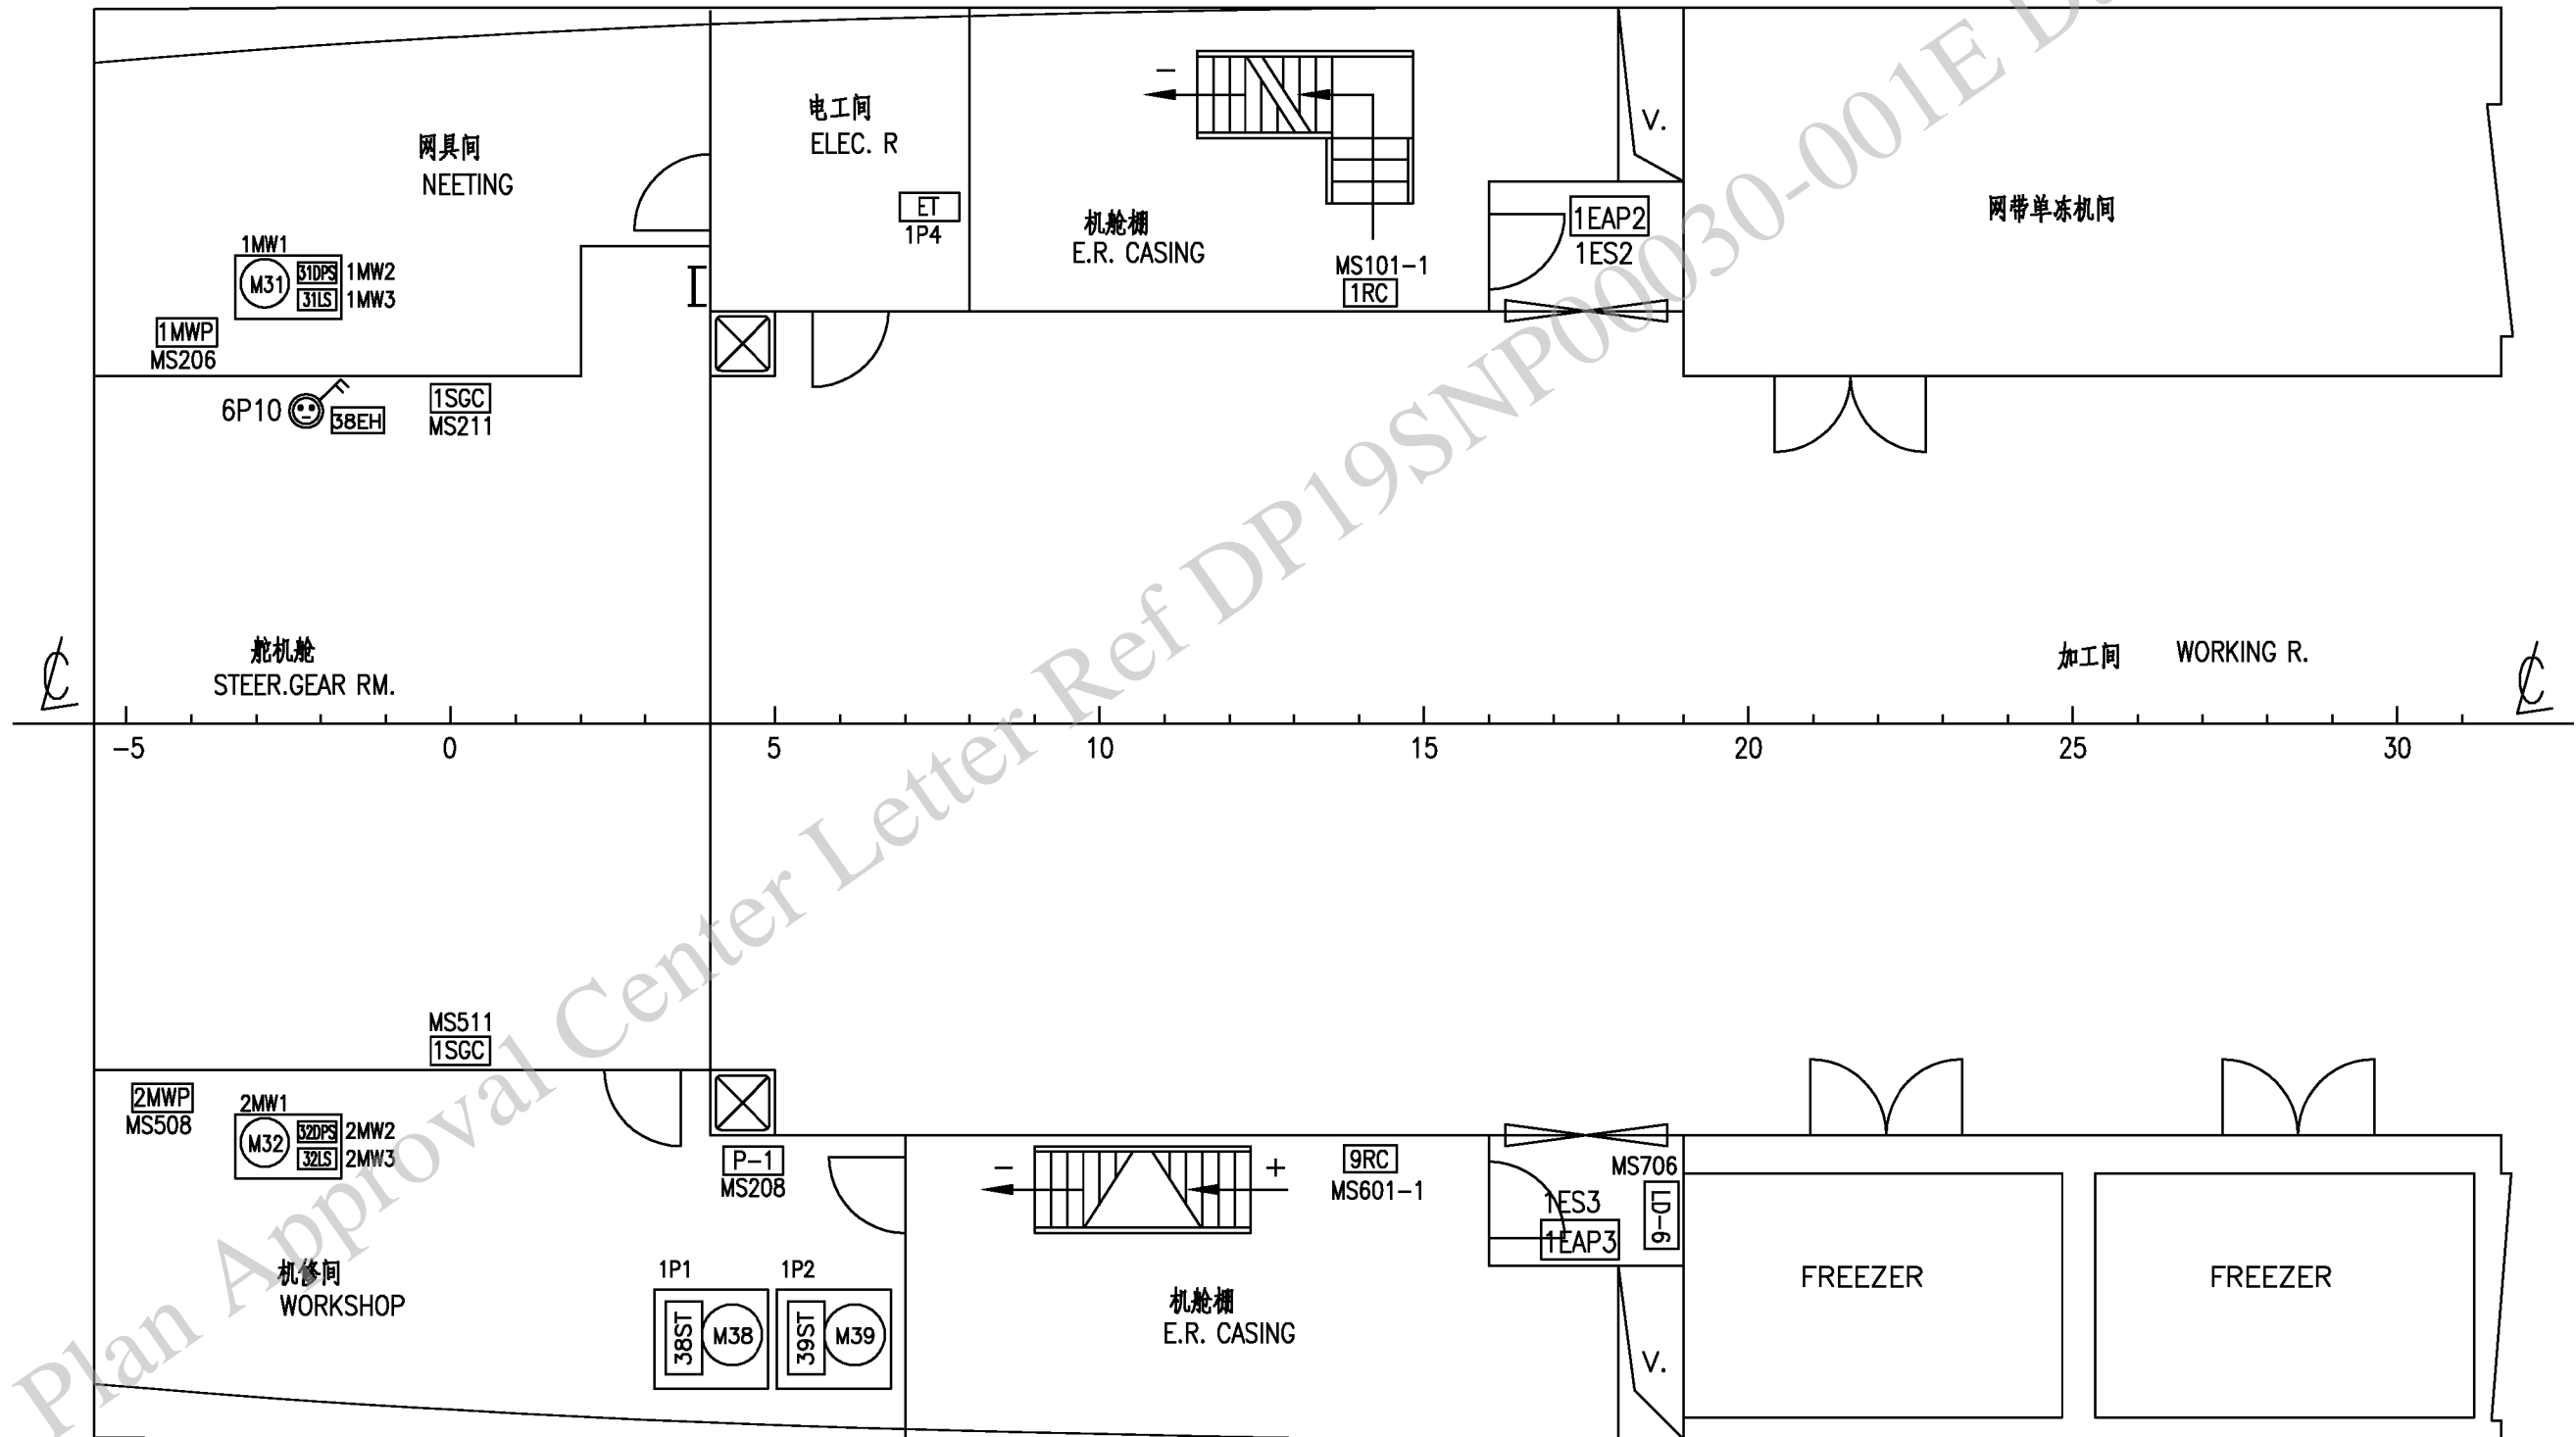

旧底图登记号

底图登记号


主甲板
MAIN DECK

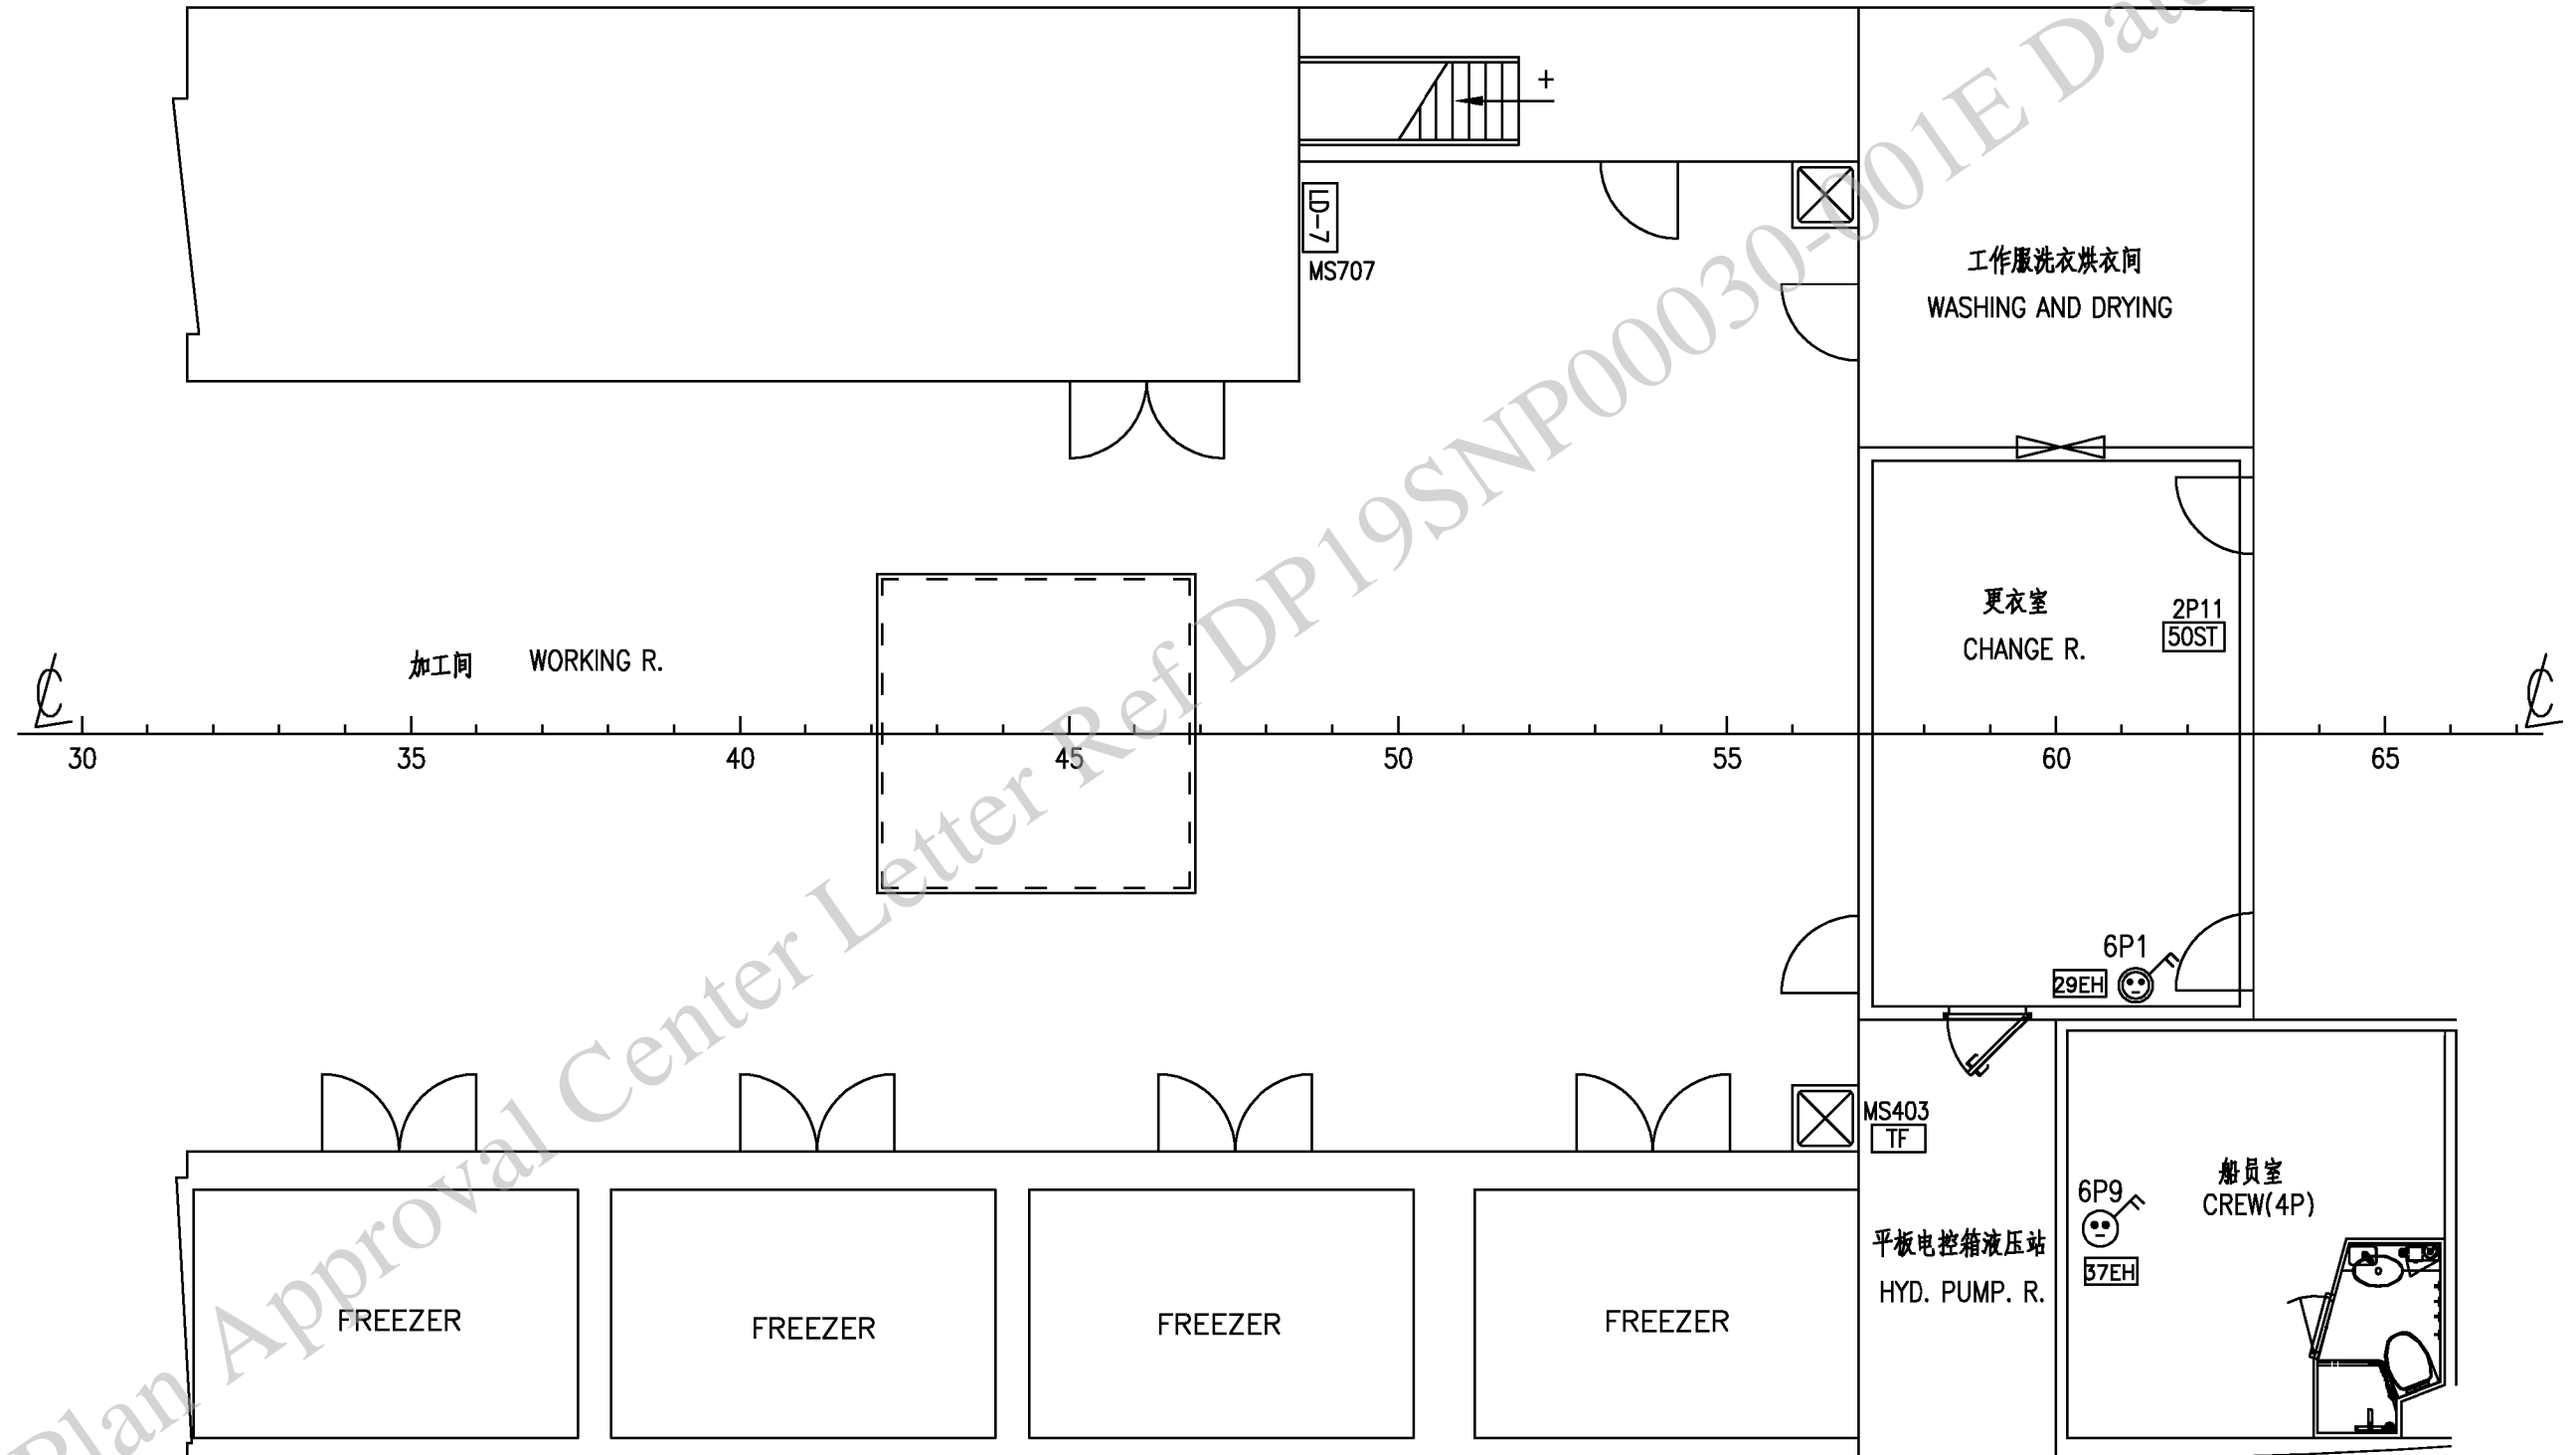

旧底图登记号

底图登记号


主甲板
MAIN DECK

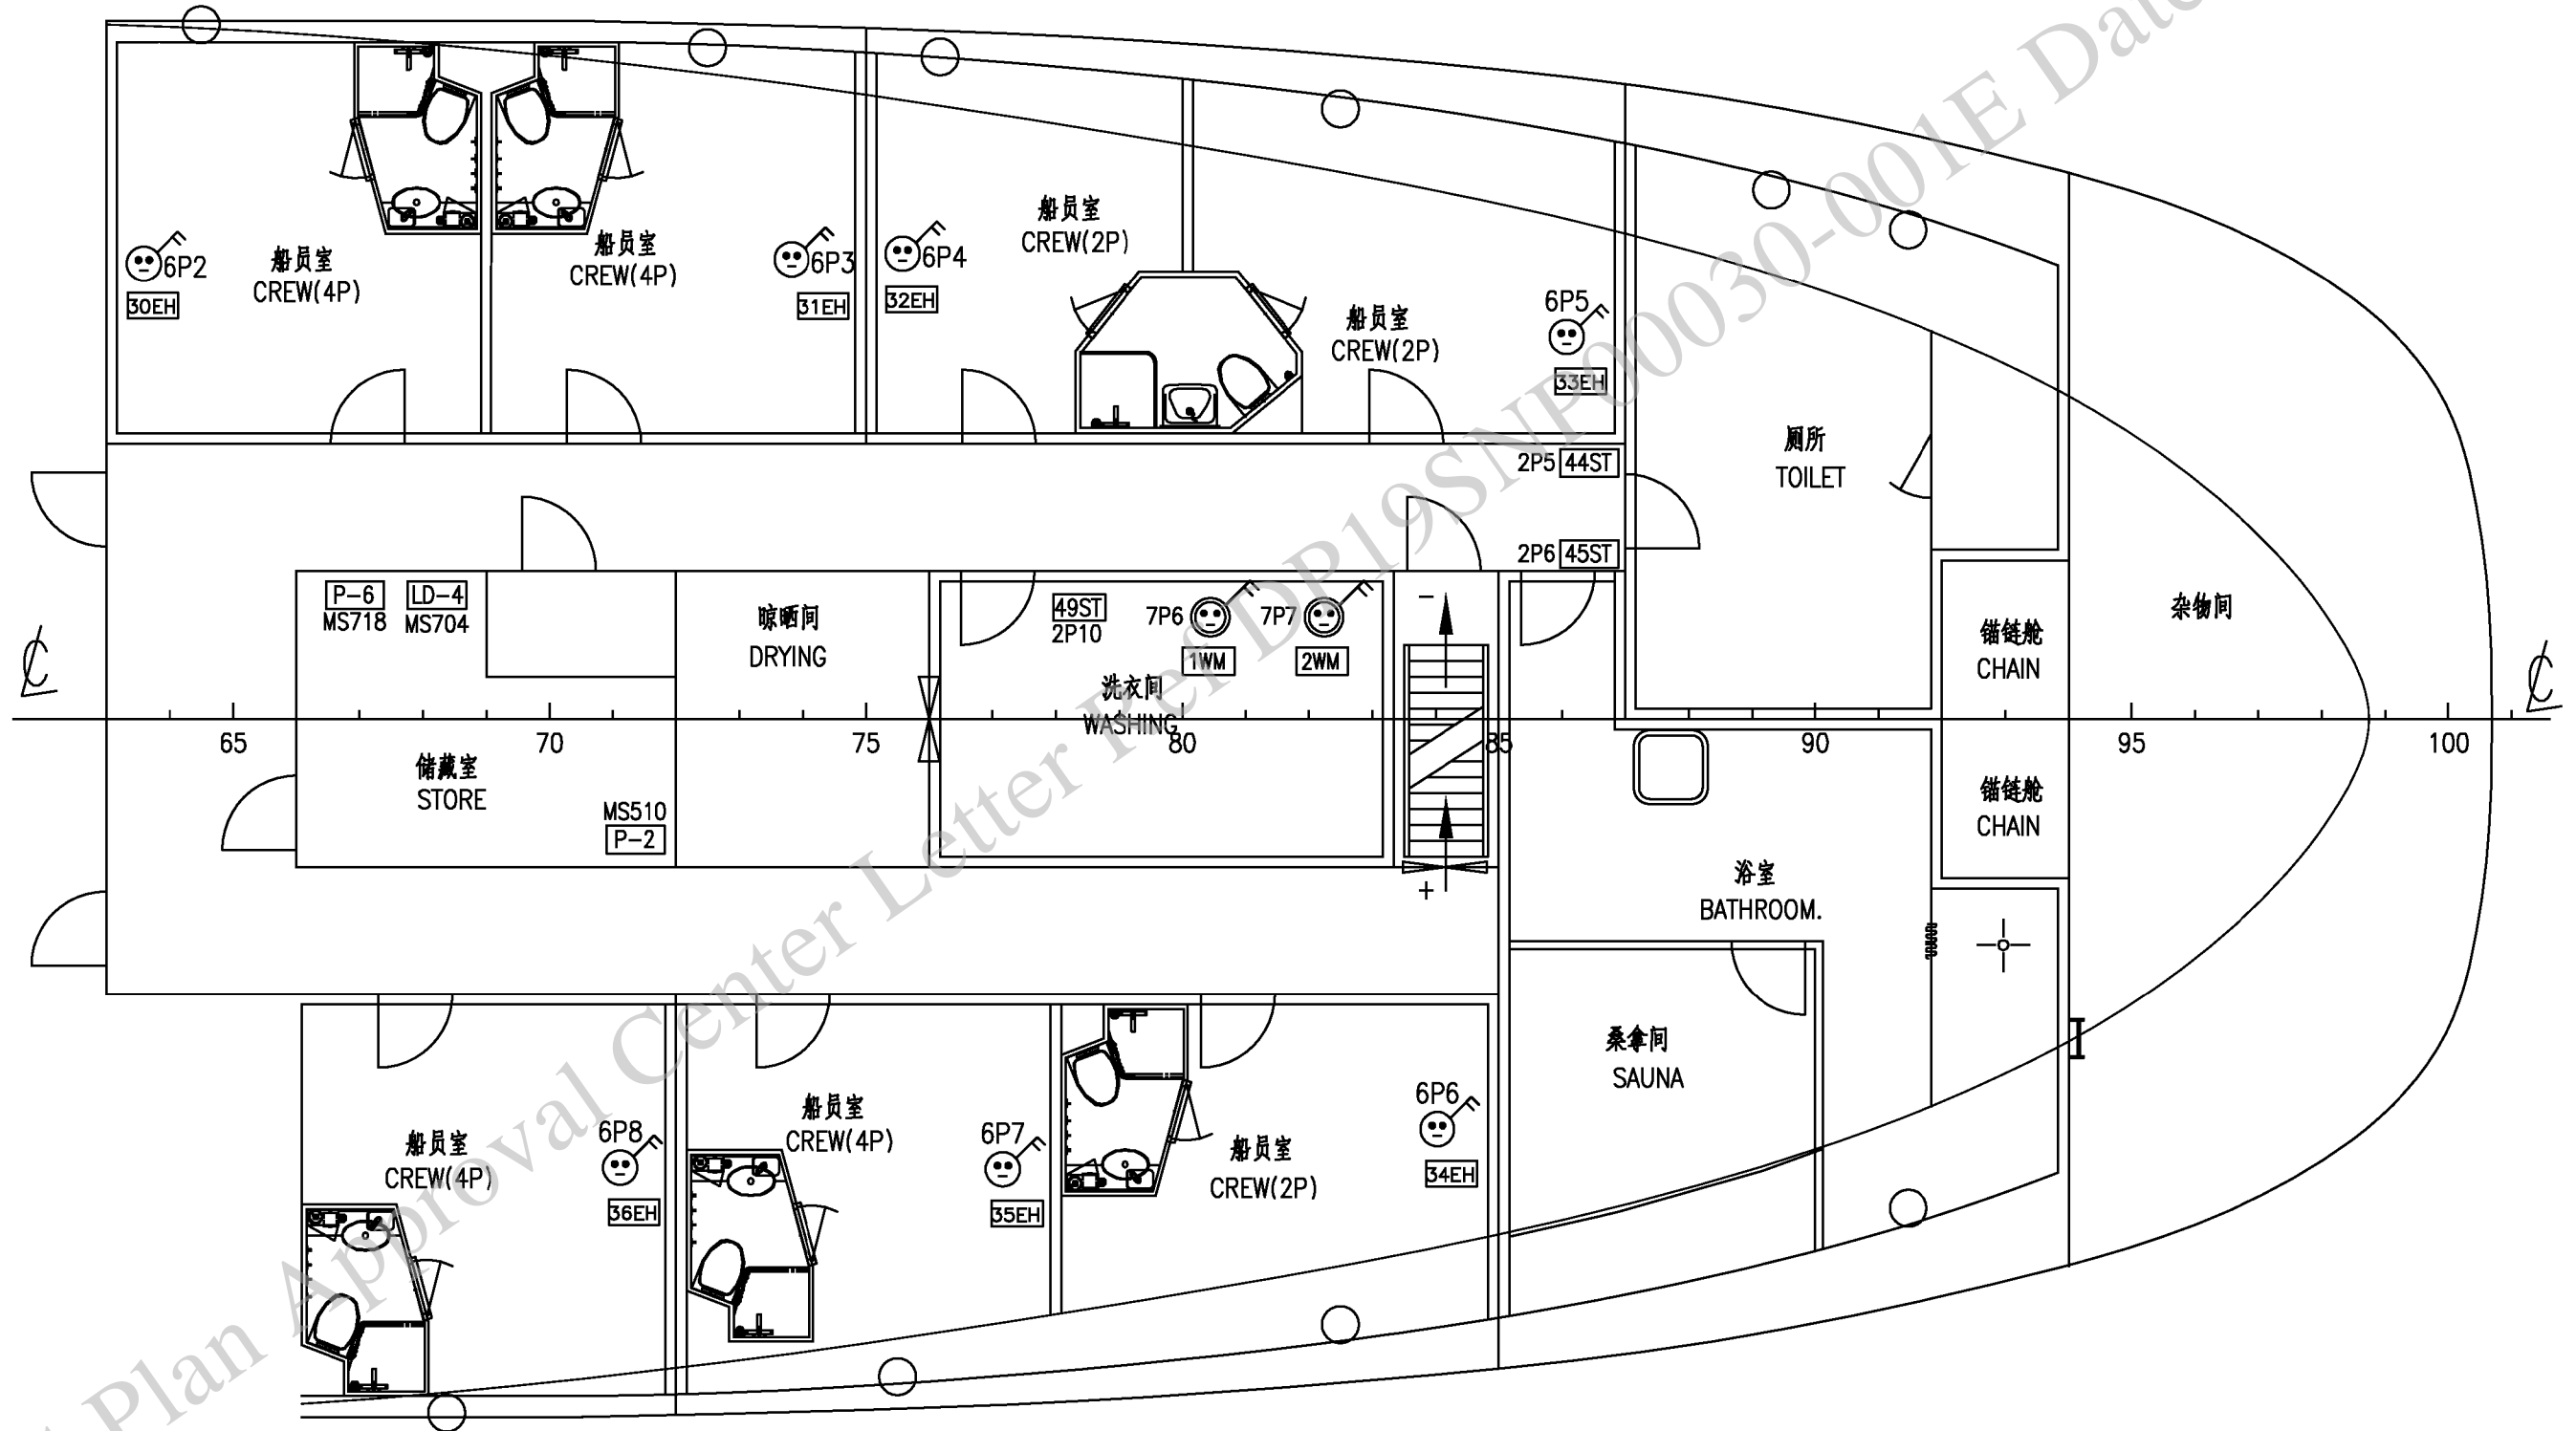

旧底图登记号


底图登记号

舱内
CABIN

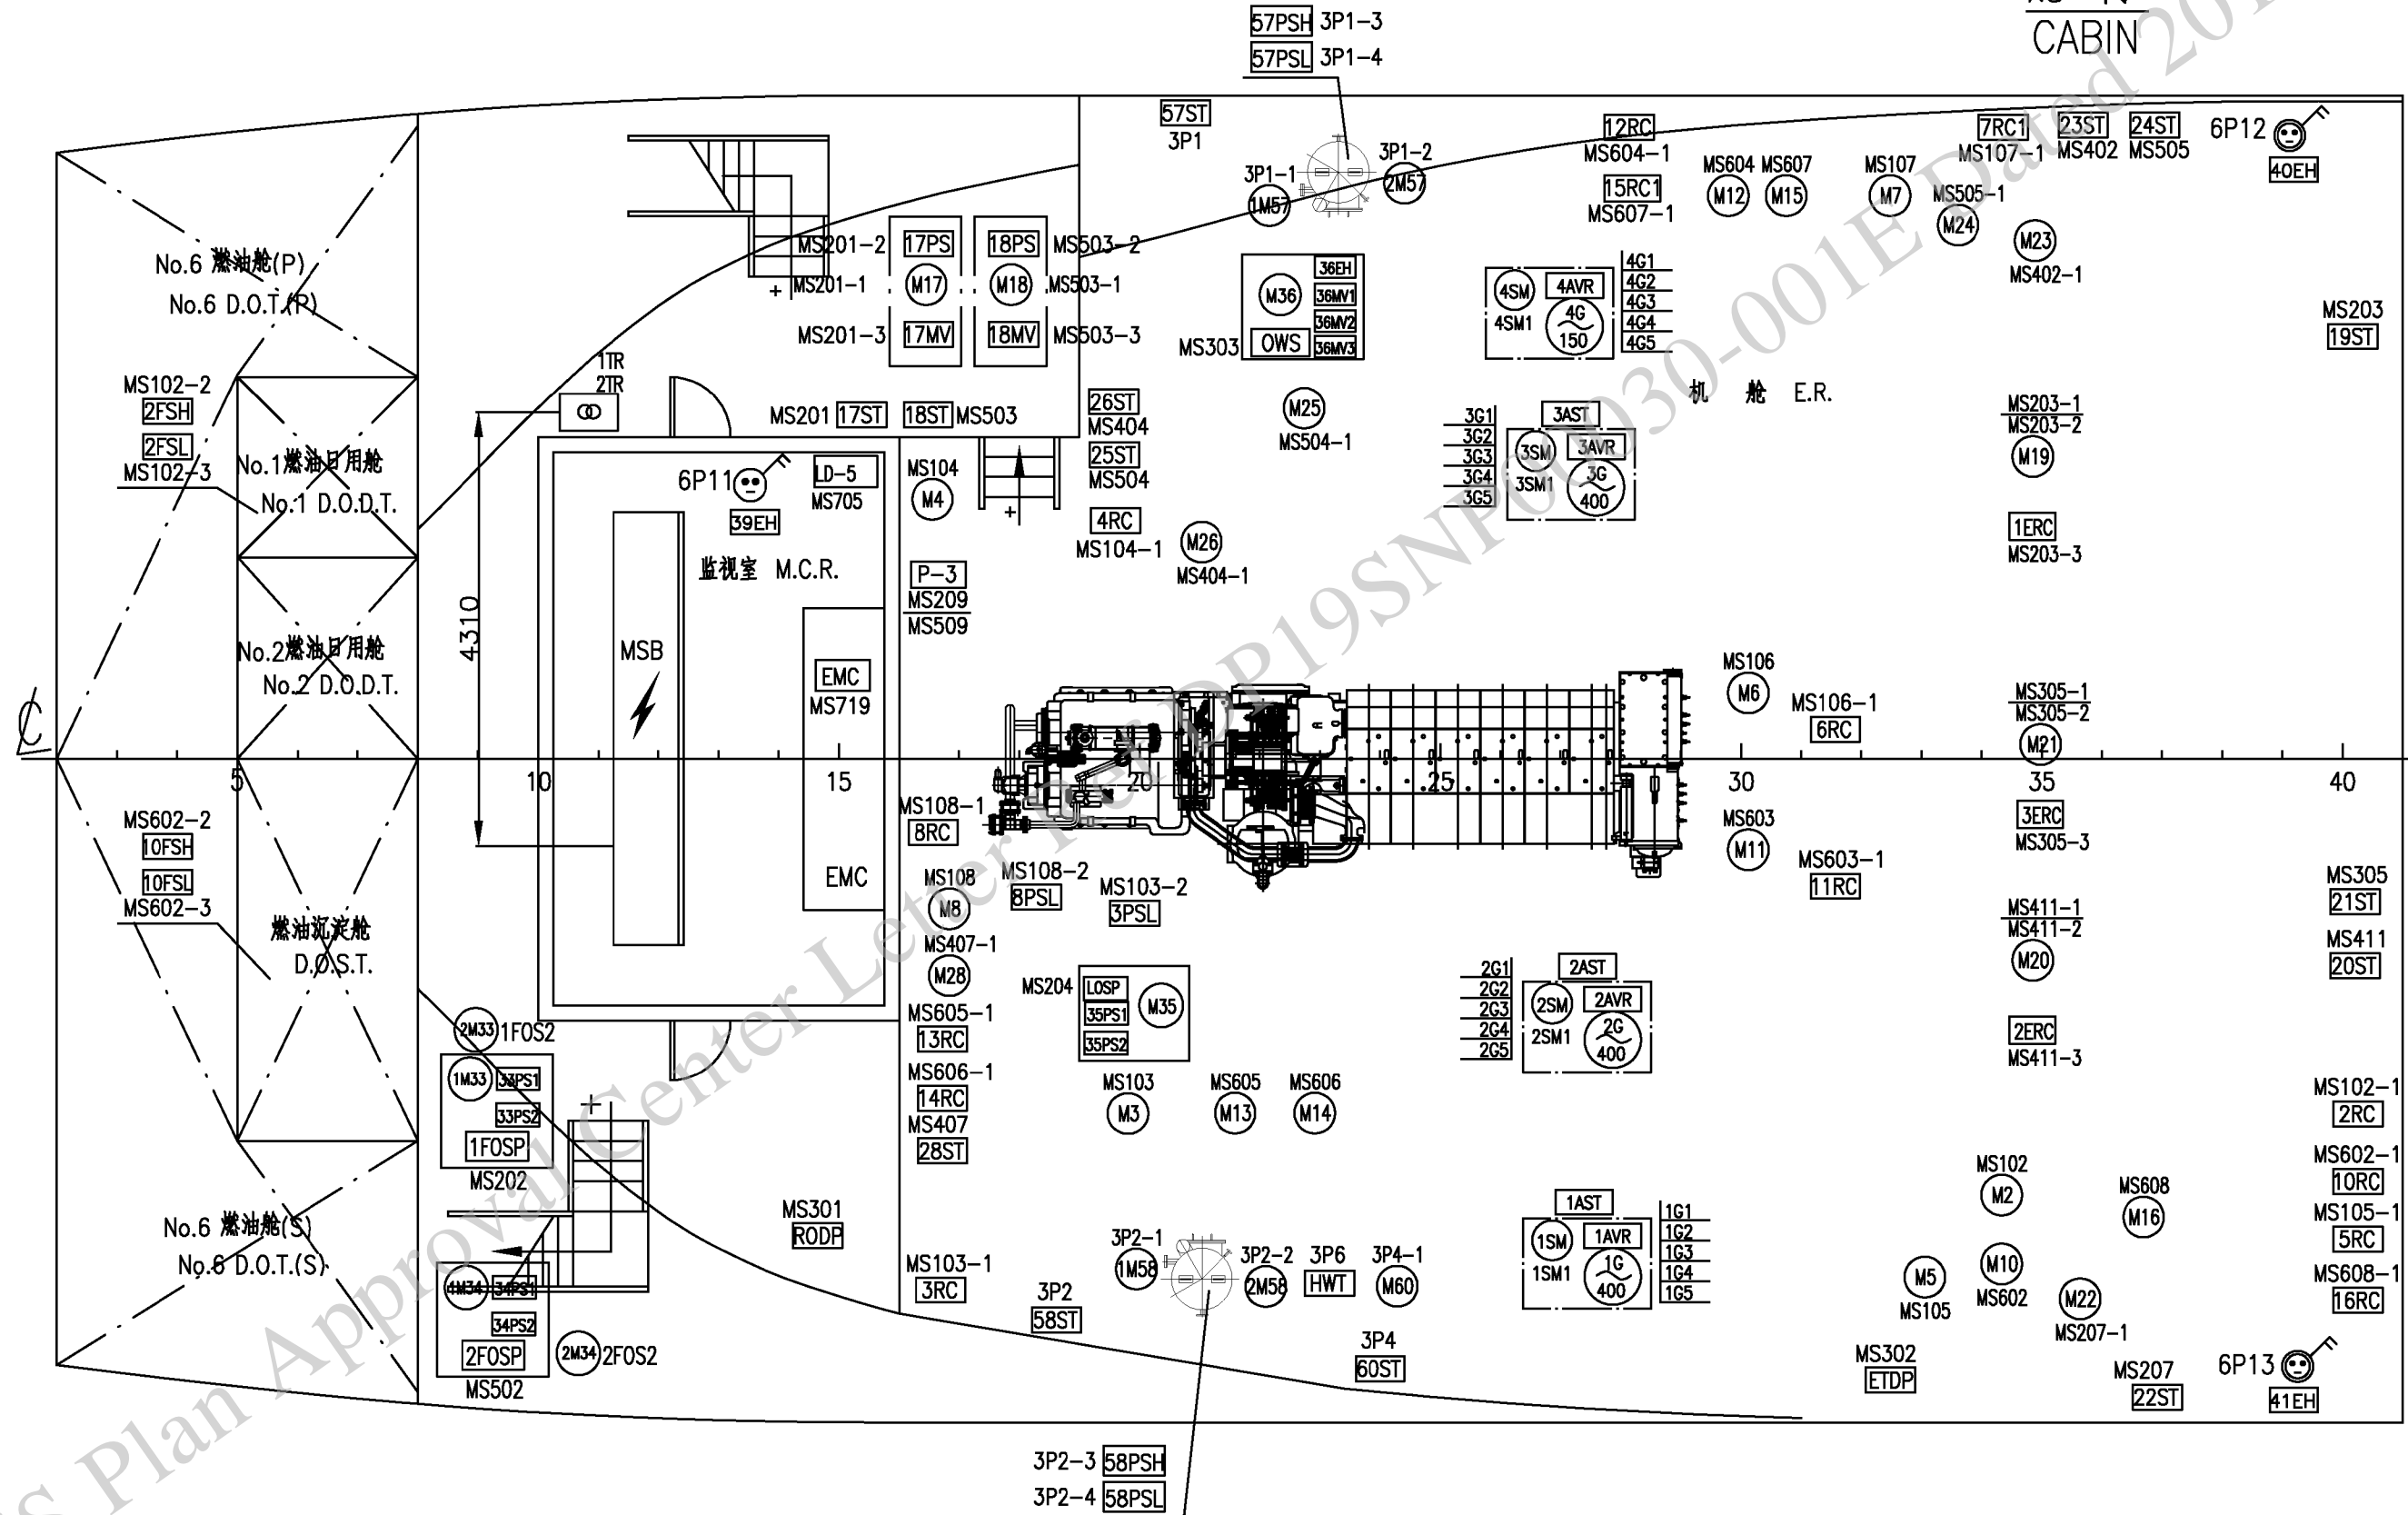

旧底图登记号

底图登记号

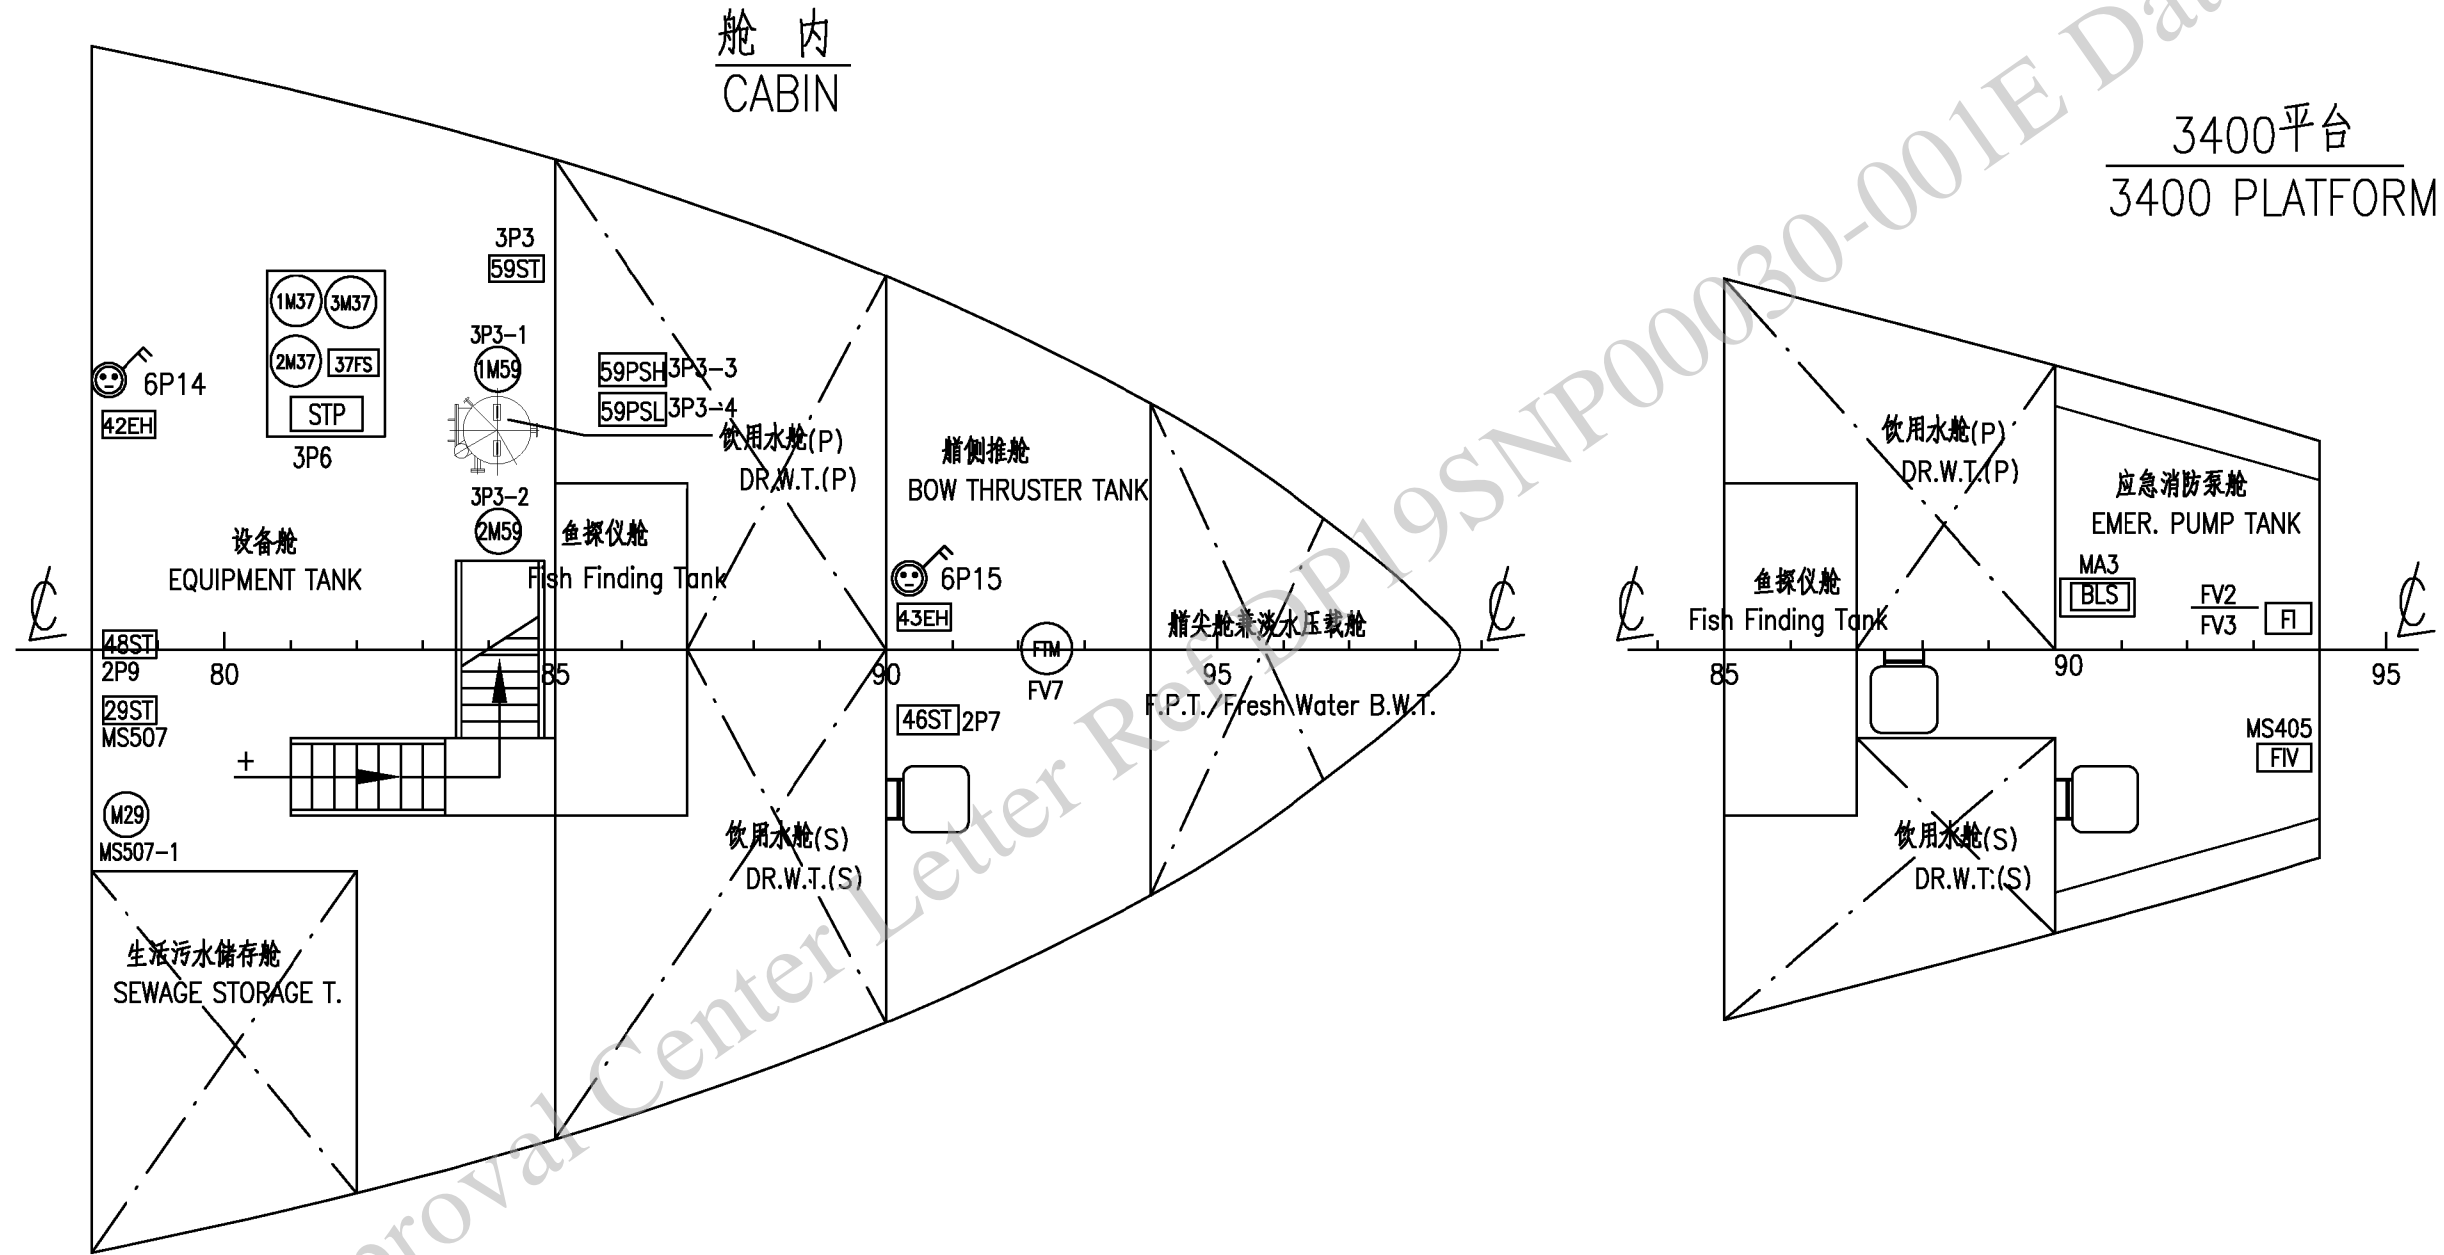

旧底图登记号

底图登记号